

RADISSON GALLERY OFFICE

RIYADH, K.S.A.

ARCHITECTURAL DRAWINGS

(GROUND FLOOR LEVEL - REVISION - 0)

(Issued for Approval)

25th. of January 2023

SUBMITTED BY:

CLIENT:



DESIGNING CONSULTANT:



NIRVANA INTERIOR DECORATION LLC.
Licence, No. 767759
Dubai, UAE.
P.O. box. 390952
Mobile: +966 505 25 24 24
Tel: +966 11 474 999 7
E-mail: info@nirvana-interiors.com
www.nirvana-interiors.com

RADISSON GALLERY

MIND[®]
FULL DESIGN SOLUTIONS

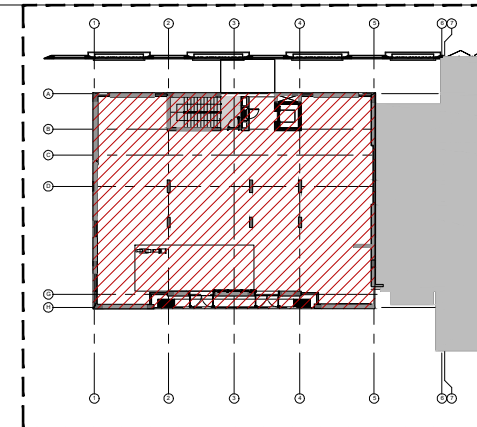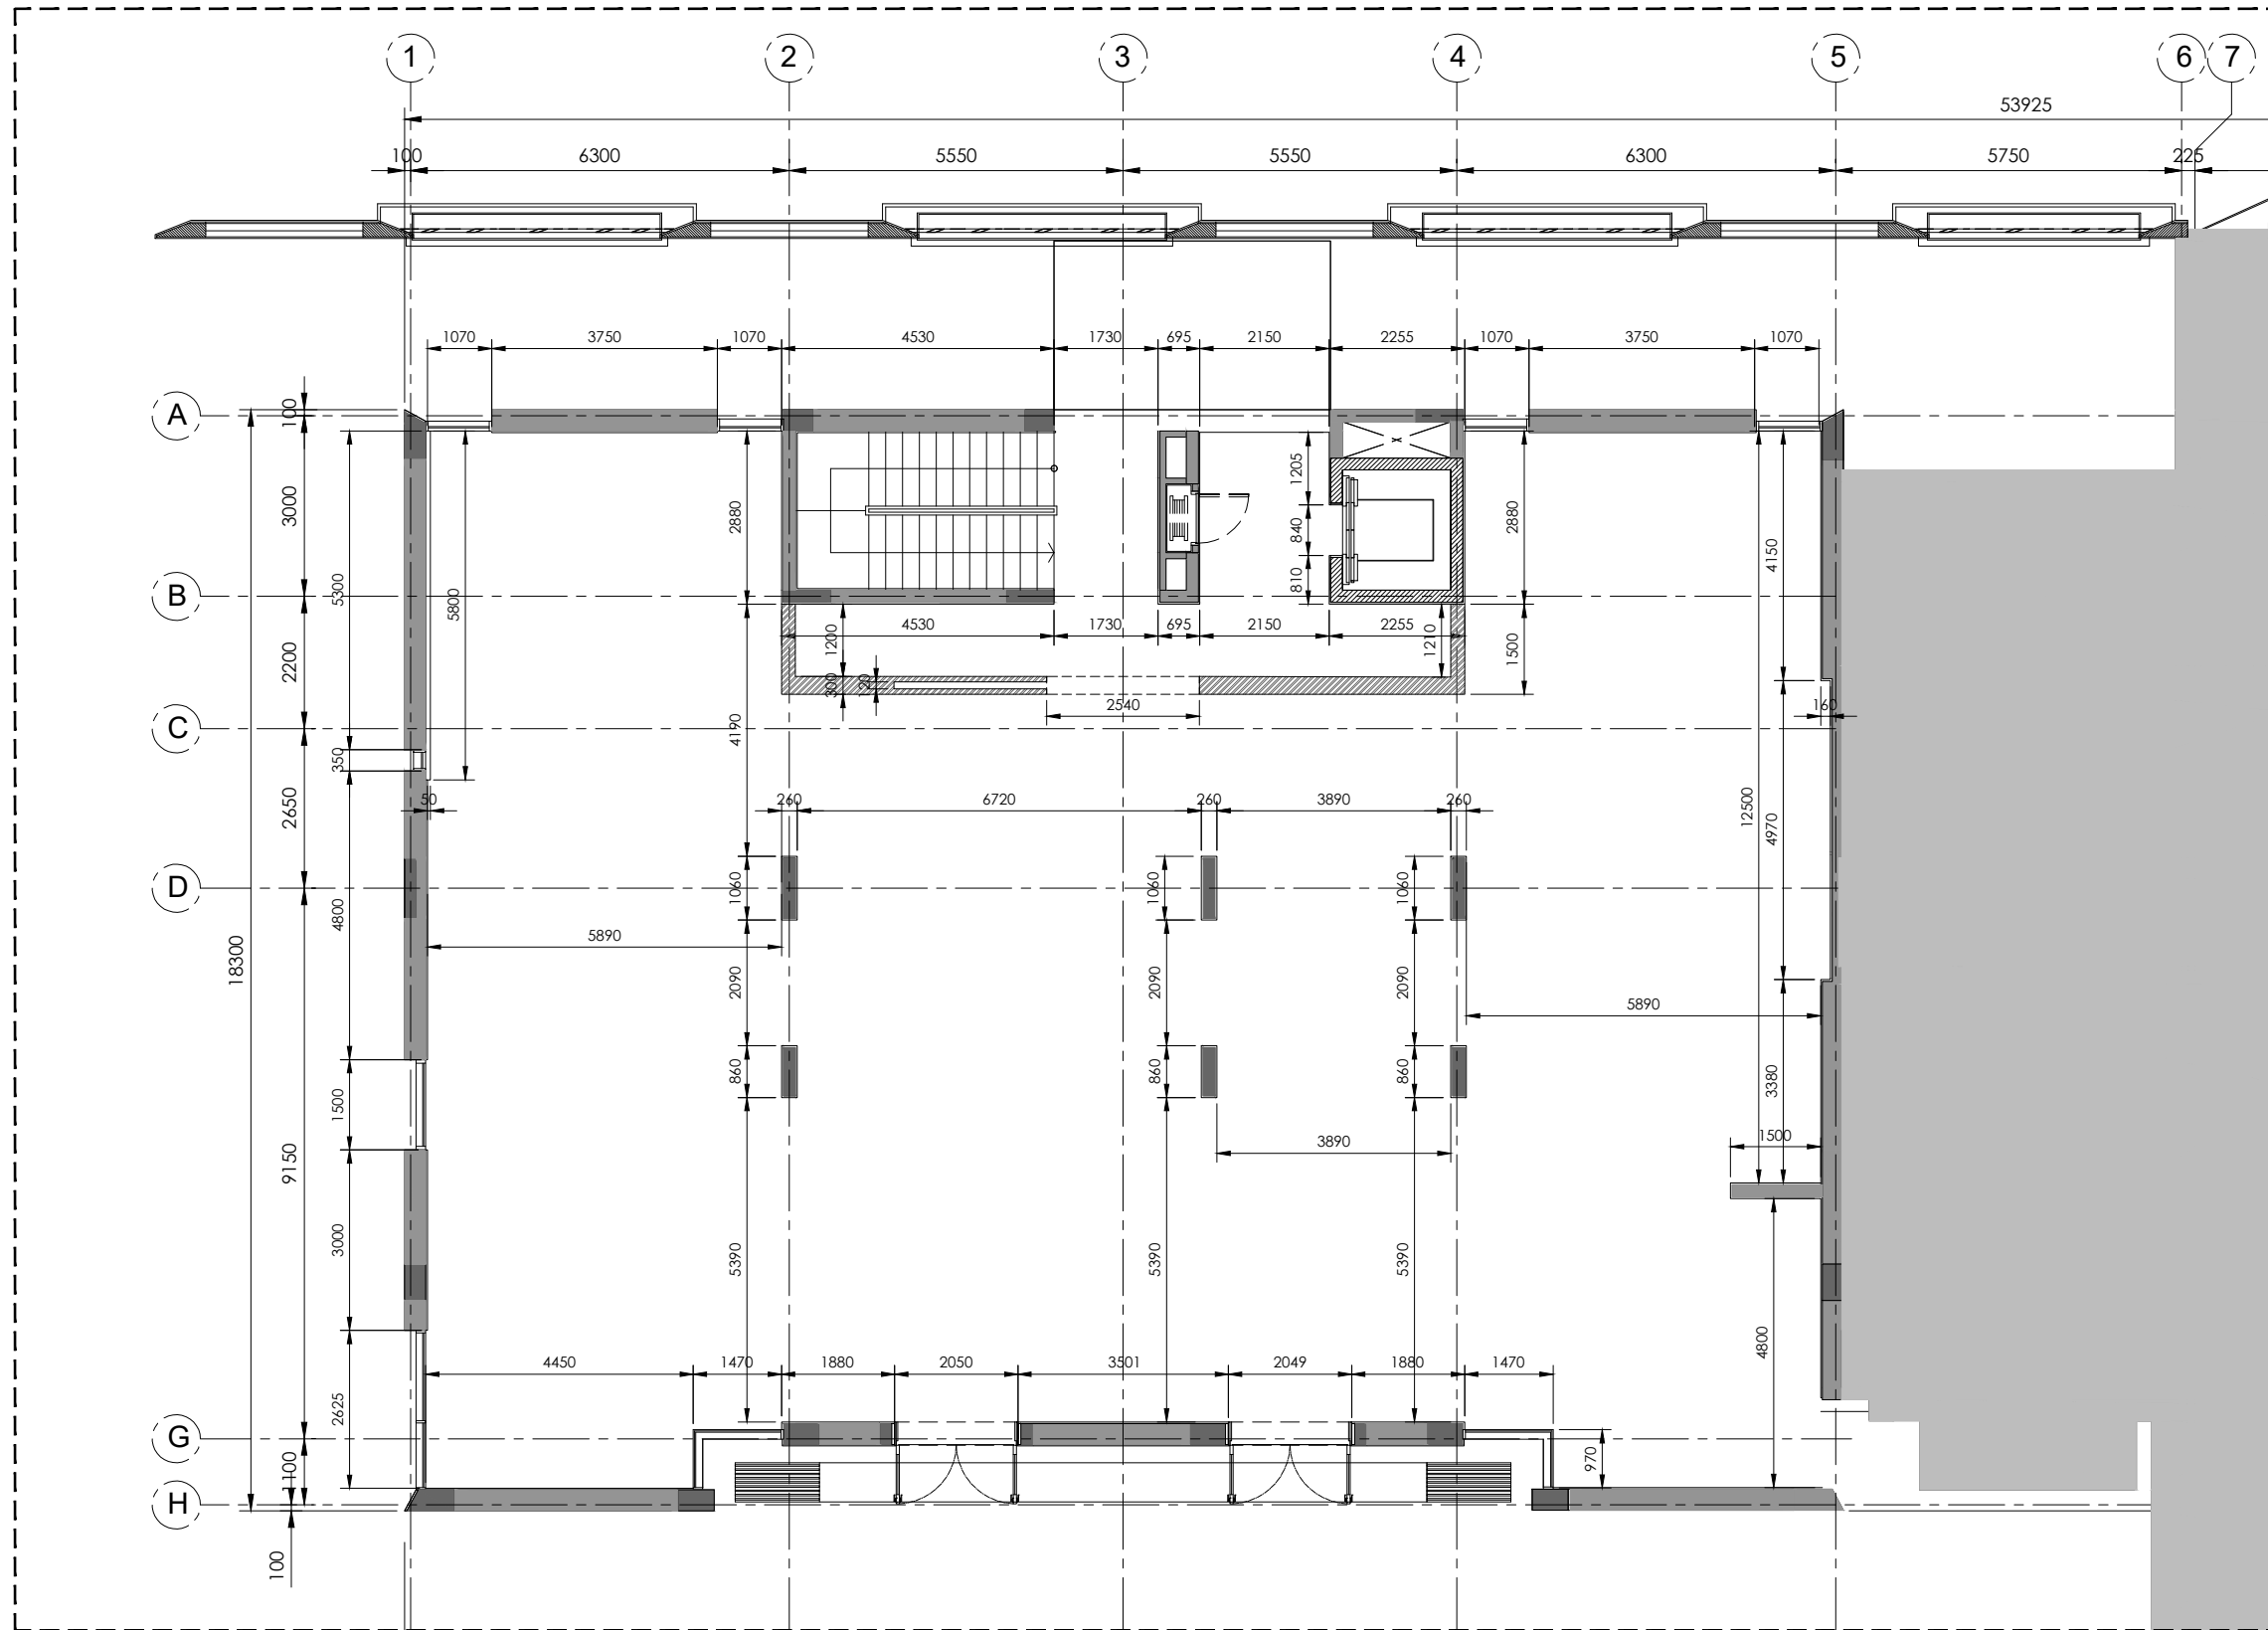

KEY PLAN

ASBUILT LAYOUT (GF)
SCALE 1:125



NIRVANA INTERIOR DECORATION LLC.
Licence, No. 767759
Dubai, UAE.
P.O. box. 390952
Mobile: +966 505 25 24 24
Tel: +966 11 474 999 7
E-mail: info@nirvana-interiors.com
www.nirvana-interiors.com

CLIENT:

RADISSON GALLERY

REVISIONS:

NO.	REVISION	DATE	BY
0	ISSUED FOR APPROVAL	11.01.2023	JD

PROJECT:

RADISSON GALLERY OFFICE
Riyadh, K.S.A.

DRAWING TITLE:

GROUND FLOOR
ASBUILT LAYOUT

DRAWING NO:

AB-01

DATE: 11.01.2023

SCALE @A3: AS SHOWN



DRAWN BY: JD

CHECKED BY: FJ

APPROVED BY: FJ

GENERAL NOTES:

- THIS DRAWING IS A COPYRIGHT.
- DIMENSIONS ARE NOT TO BE SCALED FROM THIS DRAWING.
- THE CONTRACTOR AND HIS SUBCONTRACTORS ARE TO VERIFY ALL DIMENSIONS ON SITE BEFORE MAKING ANY SHOP DRAWINGS AND BEFORE WORKS.
- ANY DISCREPANCIES, EITHER BETWEEN WRITTEN DIMENSIONS AND SITE DIMENSIONS OR BETWEEN THIS DRAWING AND OTHER CONSULTANTS' OR SUPPLIERS' DRAWINGS SHOULD BE BROUGHT TO THE IMMEDIATE ATTENTION OF NIRVANA INTERIORS BEFORE EXECUTING THE WORKS.
- THIS DRAWING IS TO BE READ IN CONJUNCTION WITH THE RELEVANT SPECIFICATIONS & DETAILS.

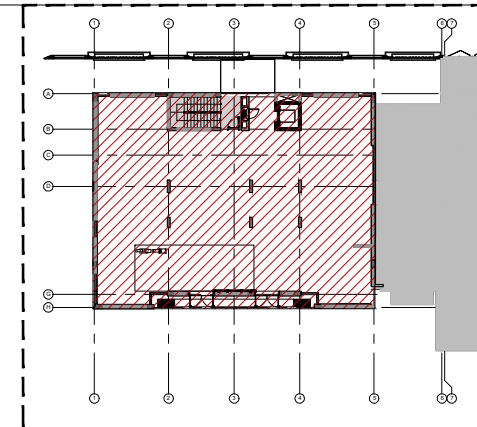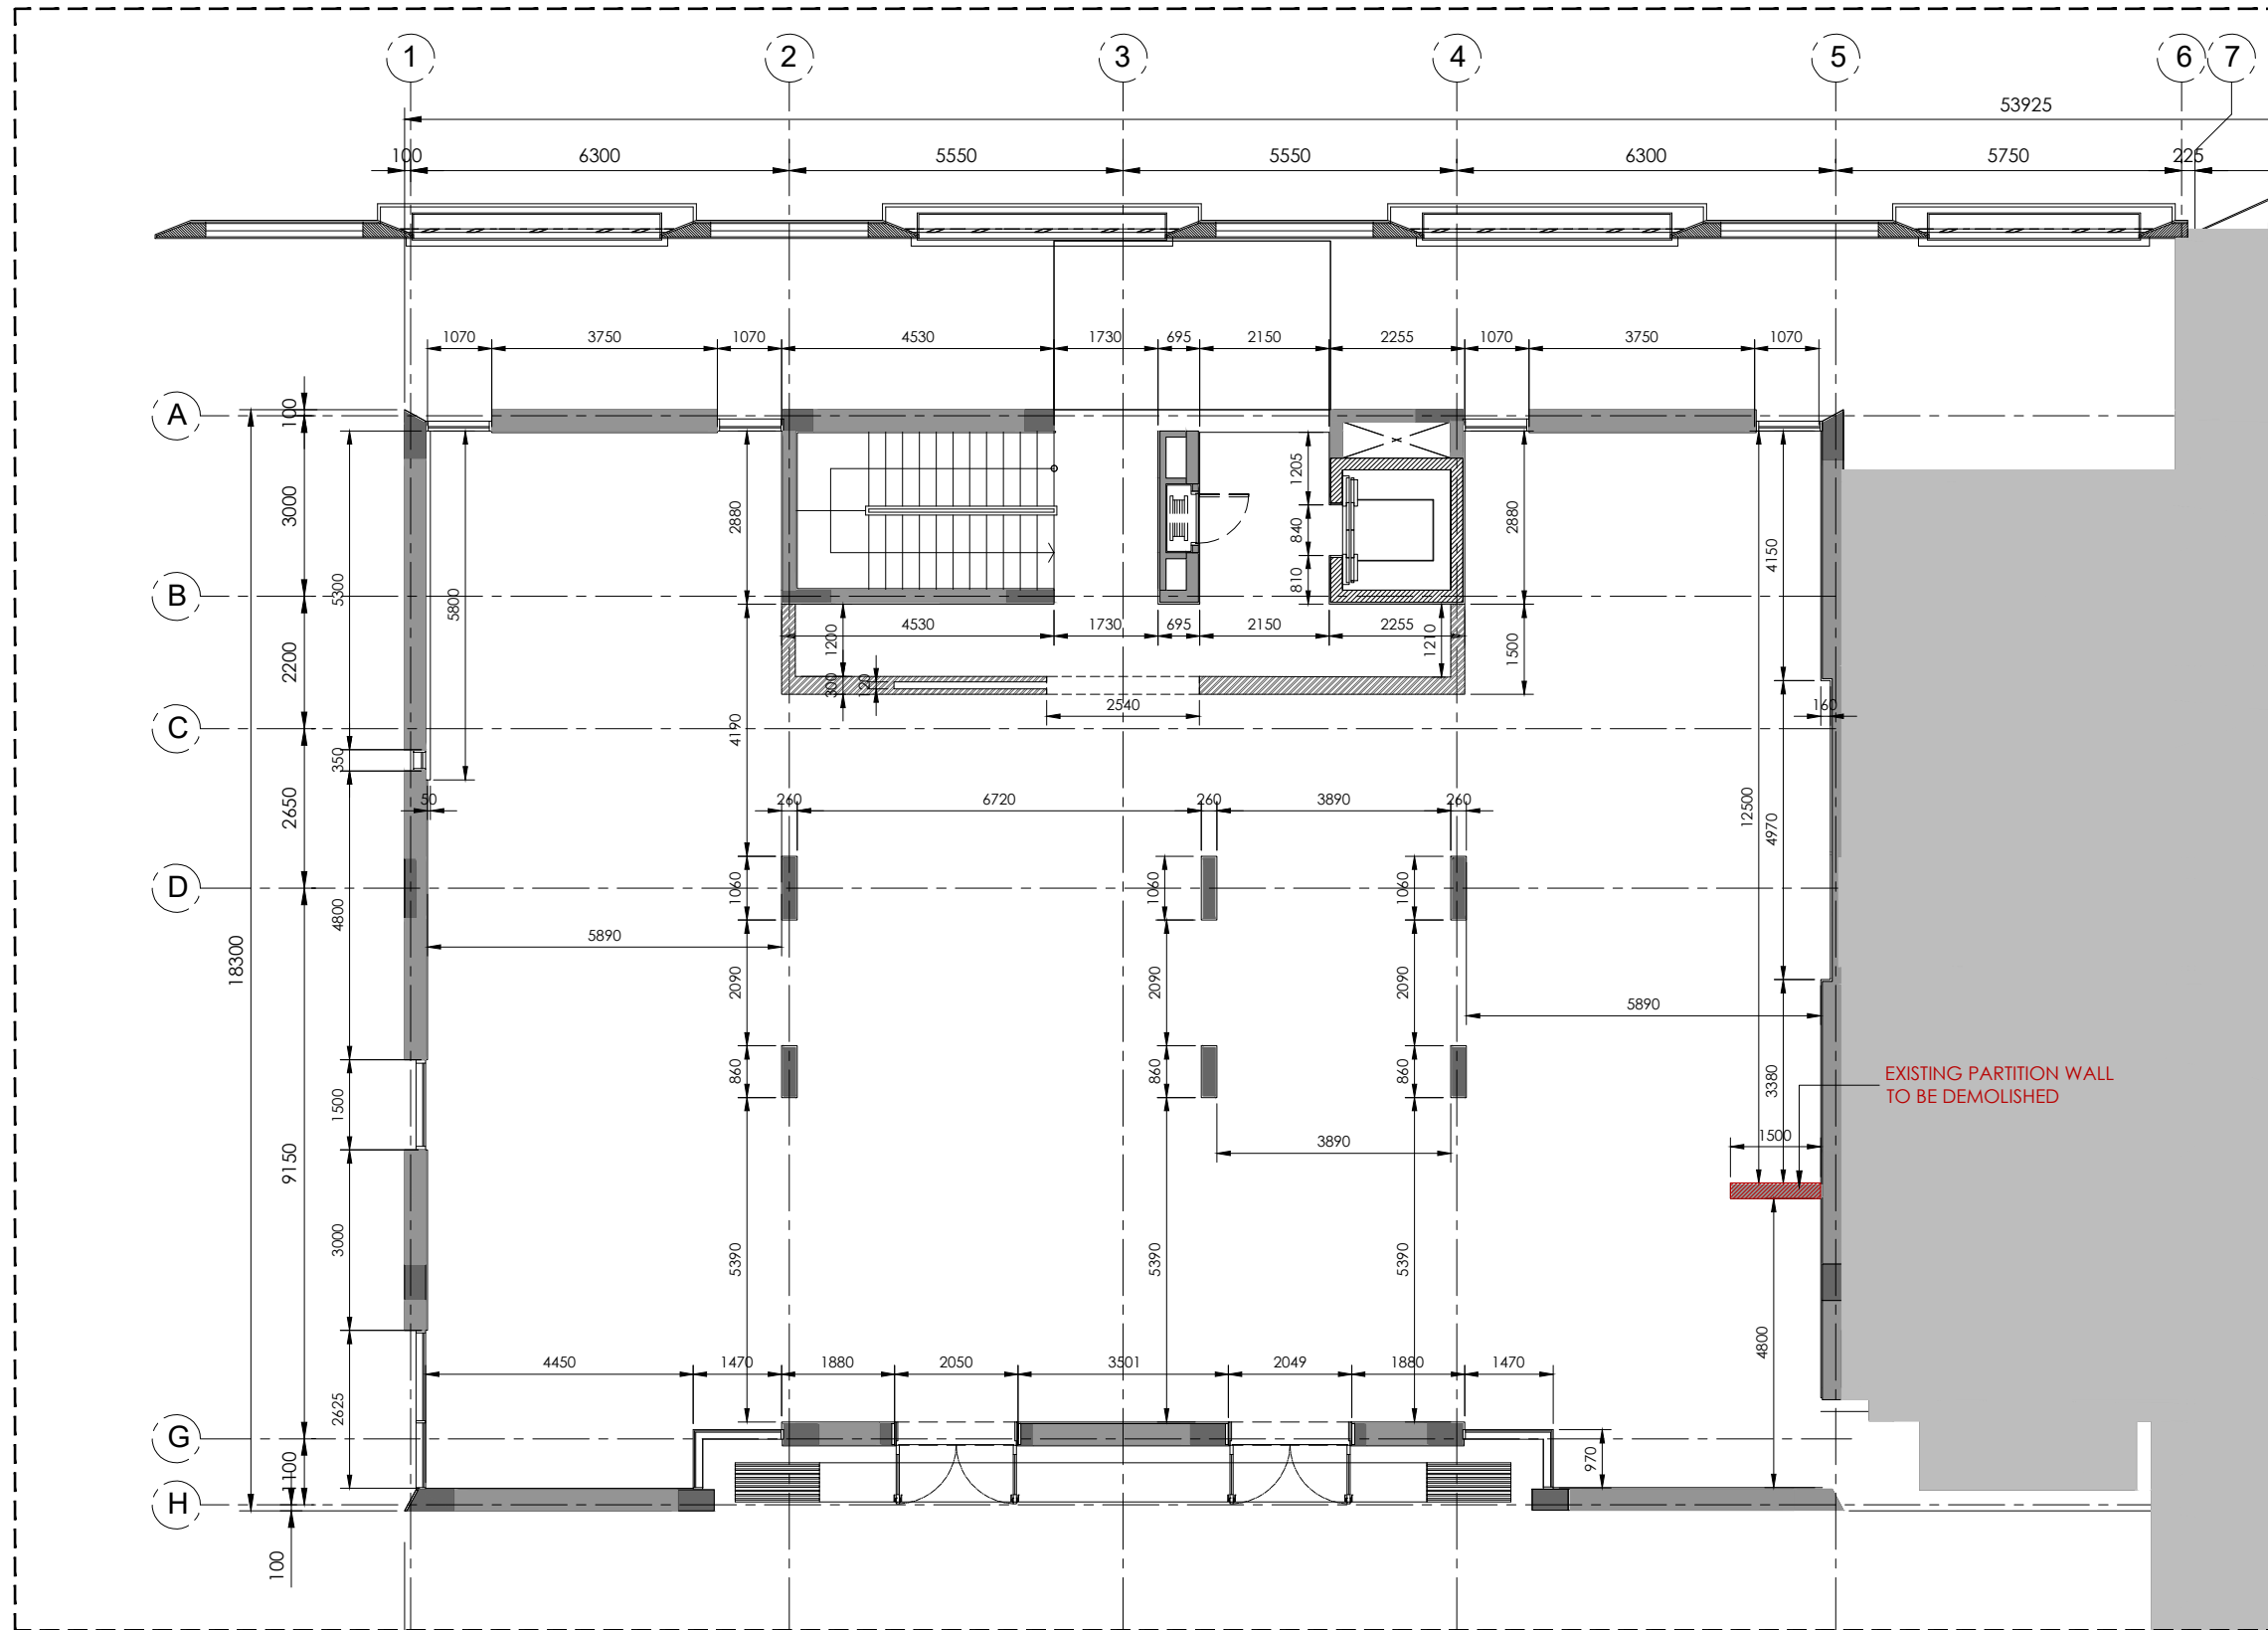

KEY PLAN

- EXISTING WALL
- TO BE DEMOLISHED

A DEMOLITION LAYOUT (GF)
DE-01 SCALE 1:125



NIRVANA INTERIOR DECORATION LLC.
Licence, No. 767759
Dubai, UAE.
P.O. box. 390952
Mobile: +966 505 25 24 24
Tel: +966 11 474 999 7
E-mail: info@nirvana-interiors.com
www.nirvana-interiors.com

CLIENT:

RADISSON GALLERY

REVISIONS:

NO.	REVISION	DATE	BY
0	ISSUED FOR APPROVAL	11.01.2023	JD

PROJECT:

RADISSON GALLERY OFFICE
Riyadh, K.S.A.

DRAWING TITLE:

GROUND FLOOR
DEMOLITION LAYOUT

DRAWING NO:

DE-01

DATE: 11.01.2023

SCALE @A3: AS SHOWN



DRAWN BY: JD

CHECKED BY: FJ

APPROVED BY: FJ

GENERAL NOTES:

- THIS DRAWING IS A COPYRIGHT.
- DIMENSIONS ARE NOT TO BE SCALED FROM THIS DRAWING.
- THE CONTRACTOR AND HIS SUBCONTRACTORS ARE TO VERIFY ALL DIMENSIONS ON SITE BEFORE MAKING ANY SHOP DRAWINGS AND BEFORE WORKS.
- ANY DISCREPANCIES, EITHER BETWEEN WRITTEN DIMENSIONS AND SITE DIMENSIONS OR BETWEEN THIS DRAWING AND OTHER CONSULTANTS' OR SUPPLIERS' DRAWINGS SHOULD BE BROUGHT TO THE IMMEDIATE ATTENTION OF NIRVANA INTERIORS BEFORE EXECUTING THE WORKS.
- THIS DRAWING IS TO BE READ IN CONJUNCTION WITH THE RELEVANT SPECIFICATIONS & DETAILS.

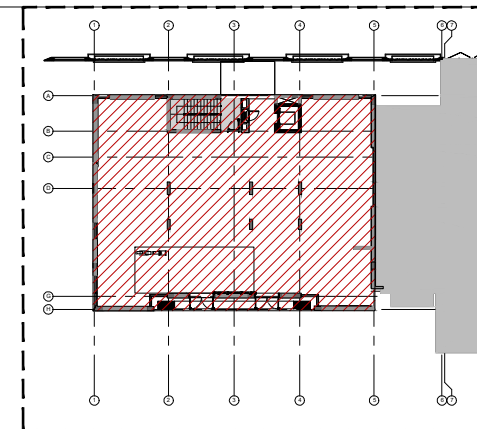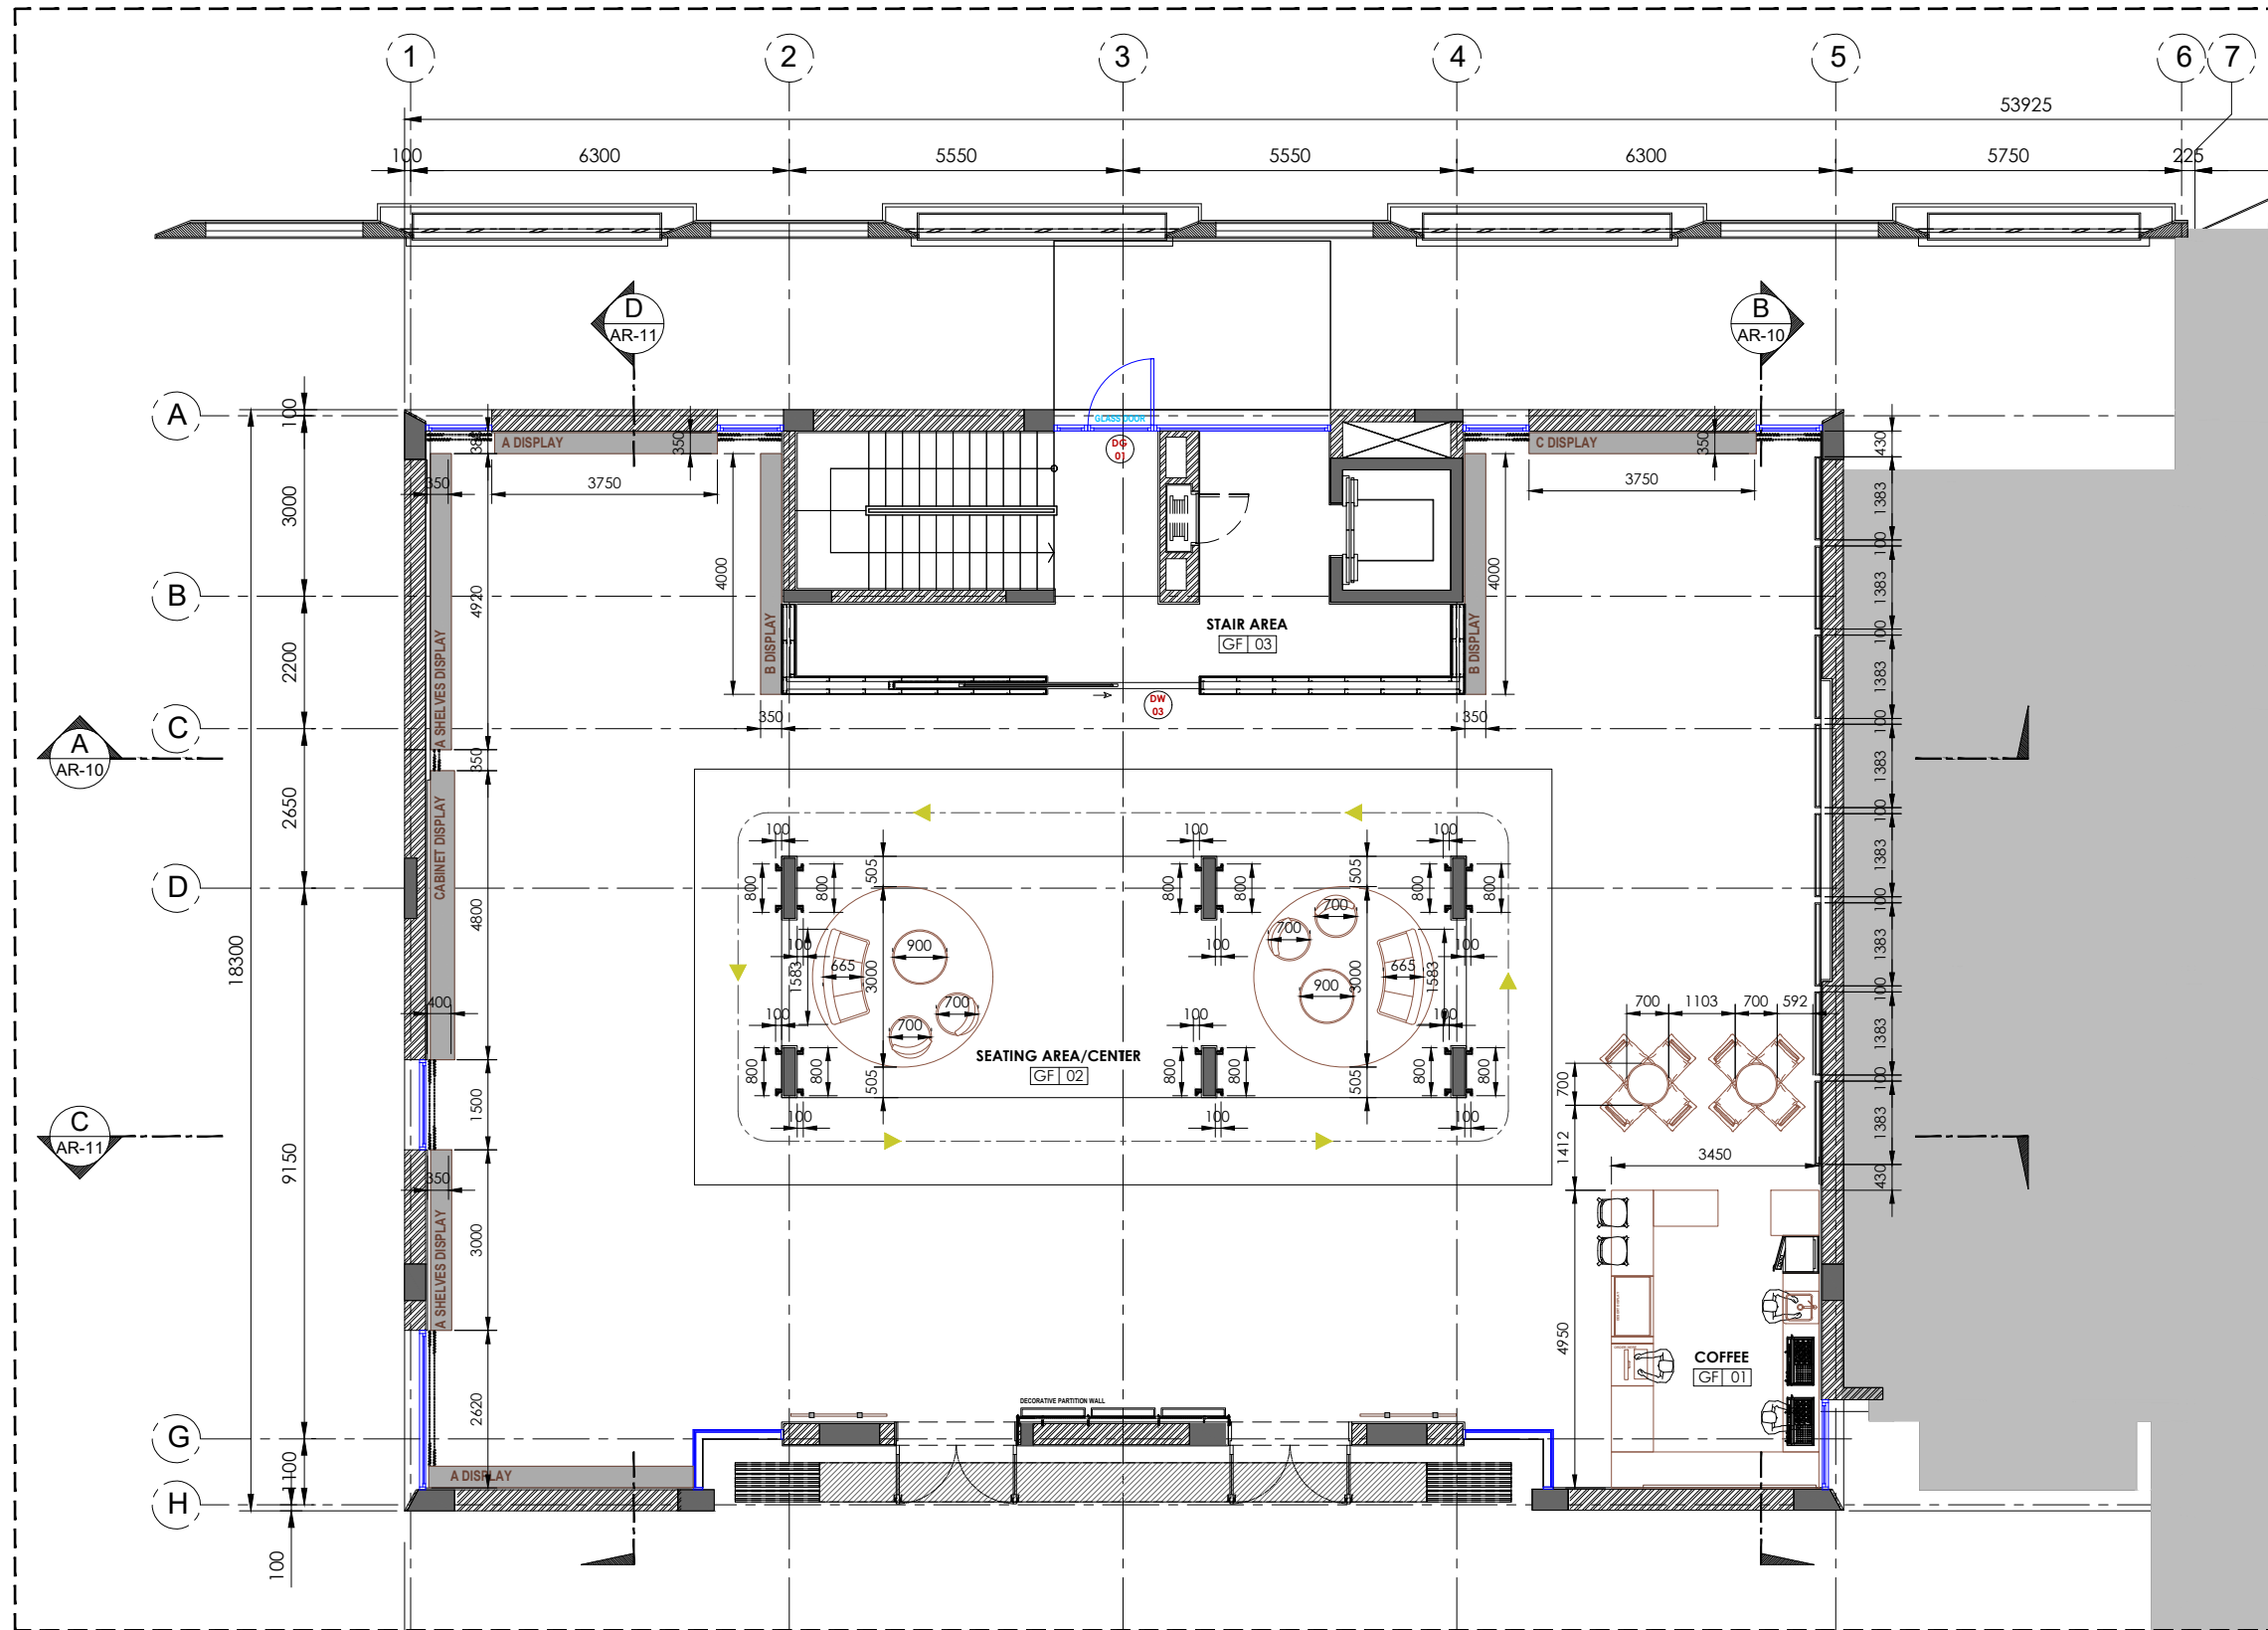

KEY PLAN

A
AR-01
FURNITURE LAYOUT (GF)
SCALE 1:125



NIRVANA INTERIOR DECORATION LLC.
Licence, No. 767759
Dubai, UAE.
P.O. box. 390952
Mobile: +966 505 25 24 24
Tel: +966 11 474 999 7
E-mail: info@nirvana-interiors.com
www.nirvana-interiors.com

CLIENT:

RADISSON GALLERY

REVISIONS:

NO.	REVISION	DATE	BY
0	ISSUED FOR APPROVAL	11.01.2023	JD

PROJECT:

RADISSON GALLERY OFFICE
Riyadh, K.S.A.

DRAWING TITLE:

GROUND FLOOR
FURNITURE LAYOUT

DRAWING NO:

AR-01

DATE: 11.01.2023

SCALE @A3: AS SHOWN



DRAWN BY: JD

CHECKED BY: FJ

APPROVED BY: FJ

GENERAL NOTES:

- THIS DRAWING IS A COPYRIGHT.
- DIMENSIONS ARE NOT TO BE SCALED FROM THIS DRAWING.
- THE CONTRACTOR AND HIS SUBCONTRACTORS ARE TO VERIFY ALL DIMENSIONS ON SITE BEFORE MAKING ANY SHOP DRAWINGS AND BEFORE WORKS.
- ANY DISCREPANCIES, EITHER BETWEEN WRITTEN DIMENSIONS AND SITE DIMENSIONS OR BETWEEN THIS DRAWING AND OTHER CONSULTANTS' OR SUPPLIERS' DRAWINGS SHOULD BE BROUGHT TO THE IMMEDIATE ATTENTION OF NIRVANA INTERIORS BEFORE EXECUTING THE WORKS.
- THIS DRAWING IS TO BE READ IN CONJUNCTION WITH THE RELEVANT SPECIFICATIONS & DETAILS.

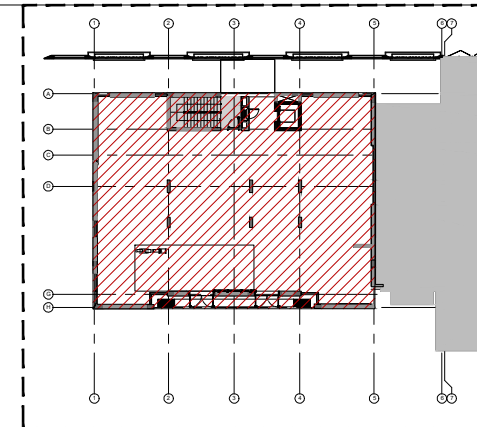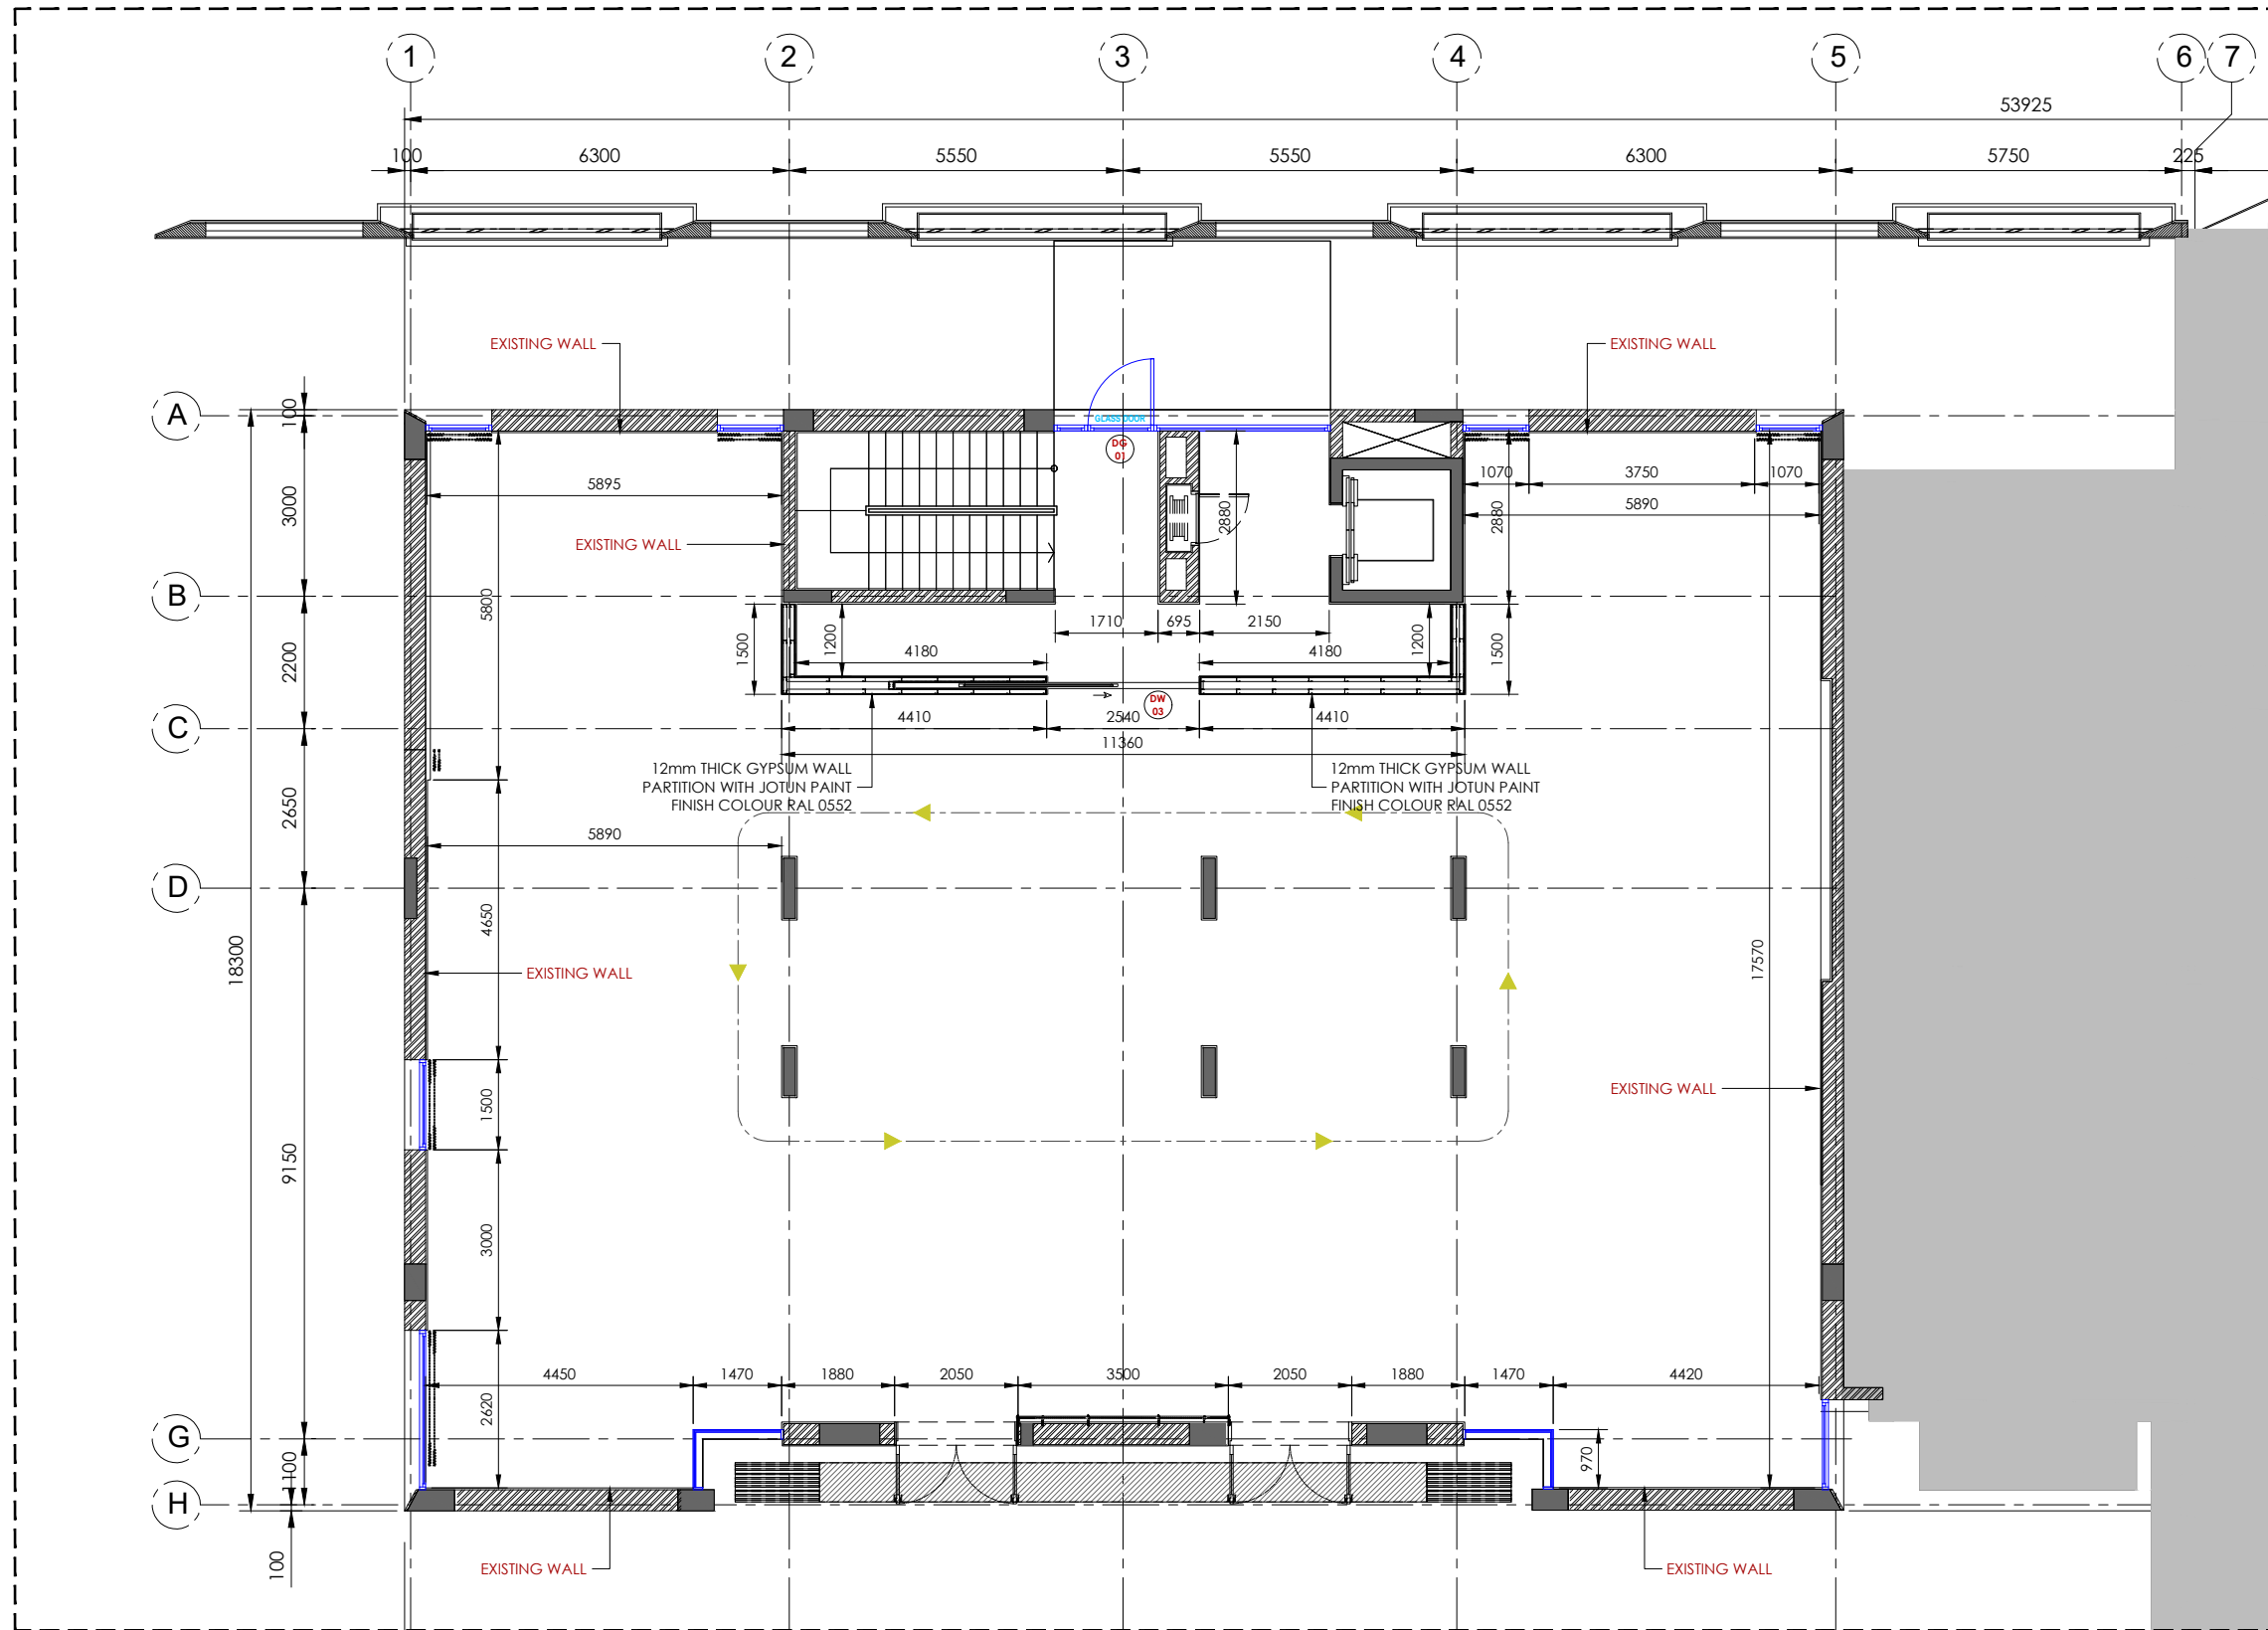

KEY PLAN

A
AR-02
PARTITION LAYOUT (GF)
SCALE 1:125



NIRVANA INTERIOR DECORATION LLC.
Licence, No. 767759
Dubai, UAE.
P.O. box. 390952
Mobile: +966 505 25 24 24
Tel: +966 11 474 999 7
E-mail: info@nirvana-interiors.com
www.nirvana-interiors.com

CLIENT:

RADISSON GALLERY

REVISIONS:

NO.	REVISION	DATE	BY
0	ISSUED FOR APPROVAL	11.01.2023	JD

PROJECT:

RADISSON GALLERY OFFICE
Riyadh, K.S.A.

DRAWING TITLE:

GROUND FLOOR
PARTITION LAYOUT

DRAWING NO:

AR-02

DATE: 11.01.2023

SCALE @A3: AS SHOWN



DRAWN BY: JD

CHECKED BY: FJ

APPROVED BY: FJ

GENERAL NOTES:

- THIS DRAWING IS A COPYRIGHT.
- DIMENSIONS ARE NOT TO BE SCALED FROM THIS DRAWING.
- THE CONTRACTOR AND HIS SUBCONTRACTORS ARE TO VERIFY ALL DIMENSIONS ON SITE BEFORE MAKING ANY SHOP DRAWINGS AND BEFORE WORKS.
- ANY DISCREPANCIES, EITHER BETWEEN WRITTEN DIMENSIONS AND SITE DIMENSIONS OR BETWEEN THIS DRAWING AND OTHER CONSULTANTS' OR SUPPLIERS' DRAWINGS SHOULD BE BROUGHT TO THE IMMEDIATE ATTENTION OF NIRVANA INTERIORS BEFORE EXECUTING THE WORKS.
- THIS DRAWING IS TO BE READ IN CONJUNCTION WITH THE RELEVANT SPECIFICATIONS & DETAILS.

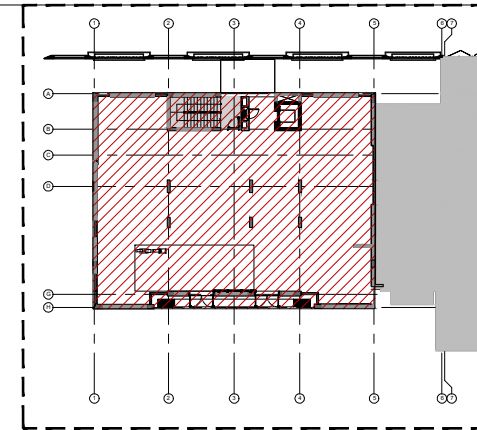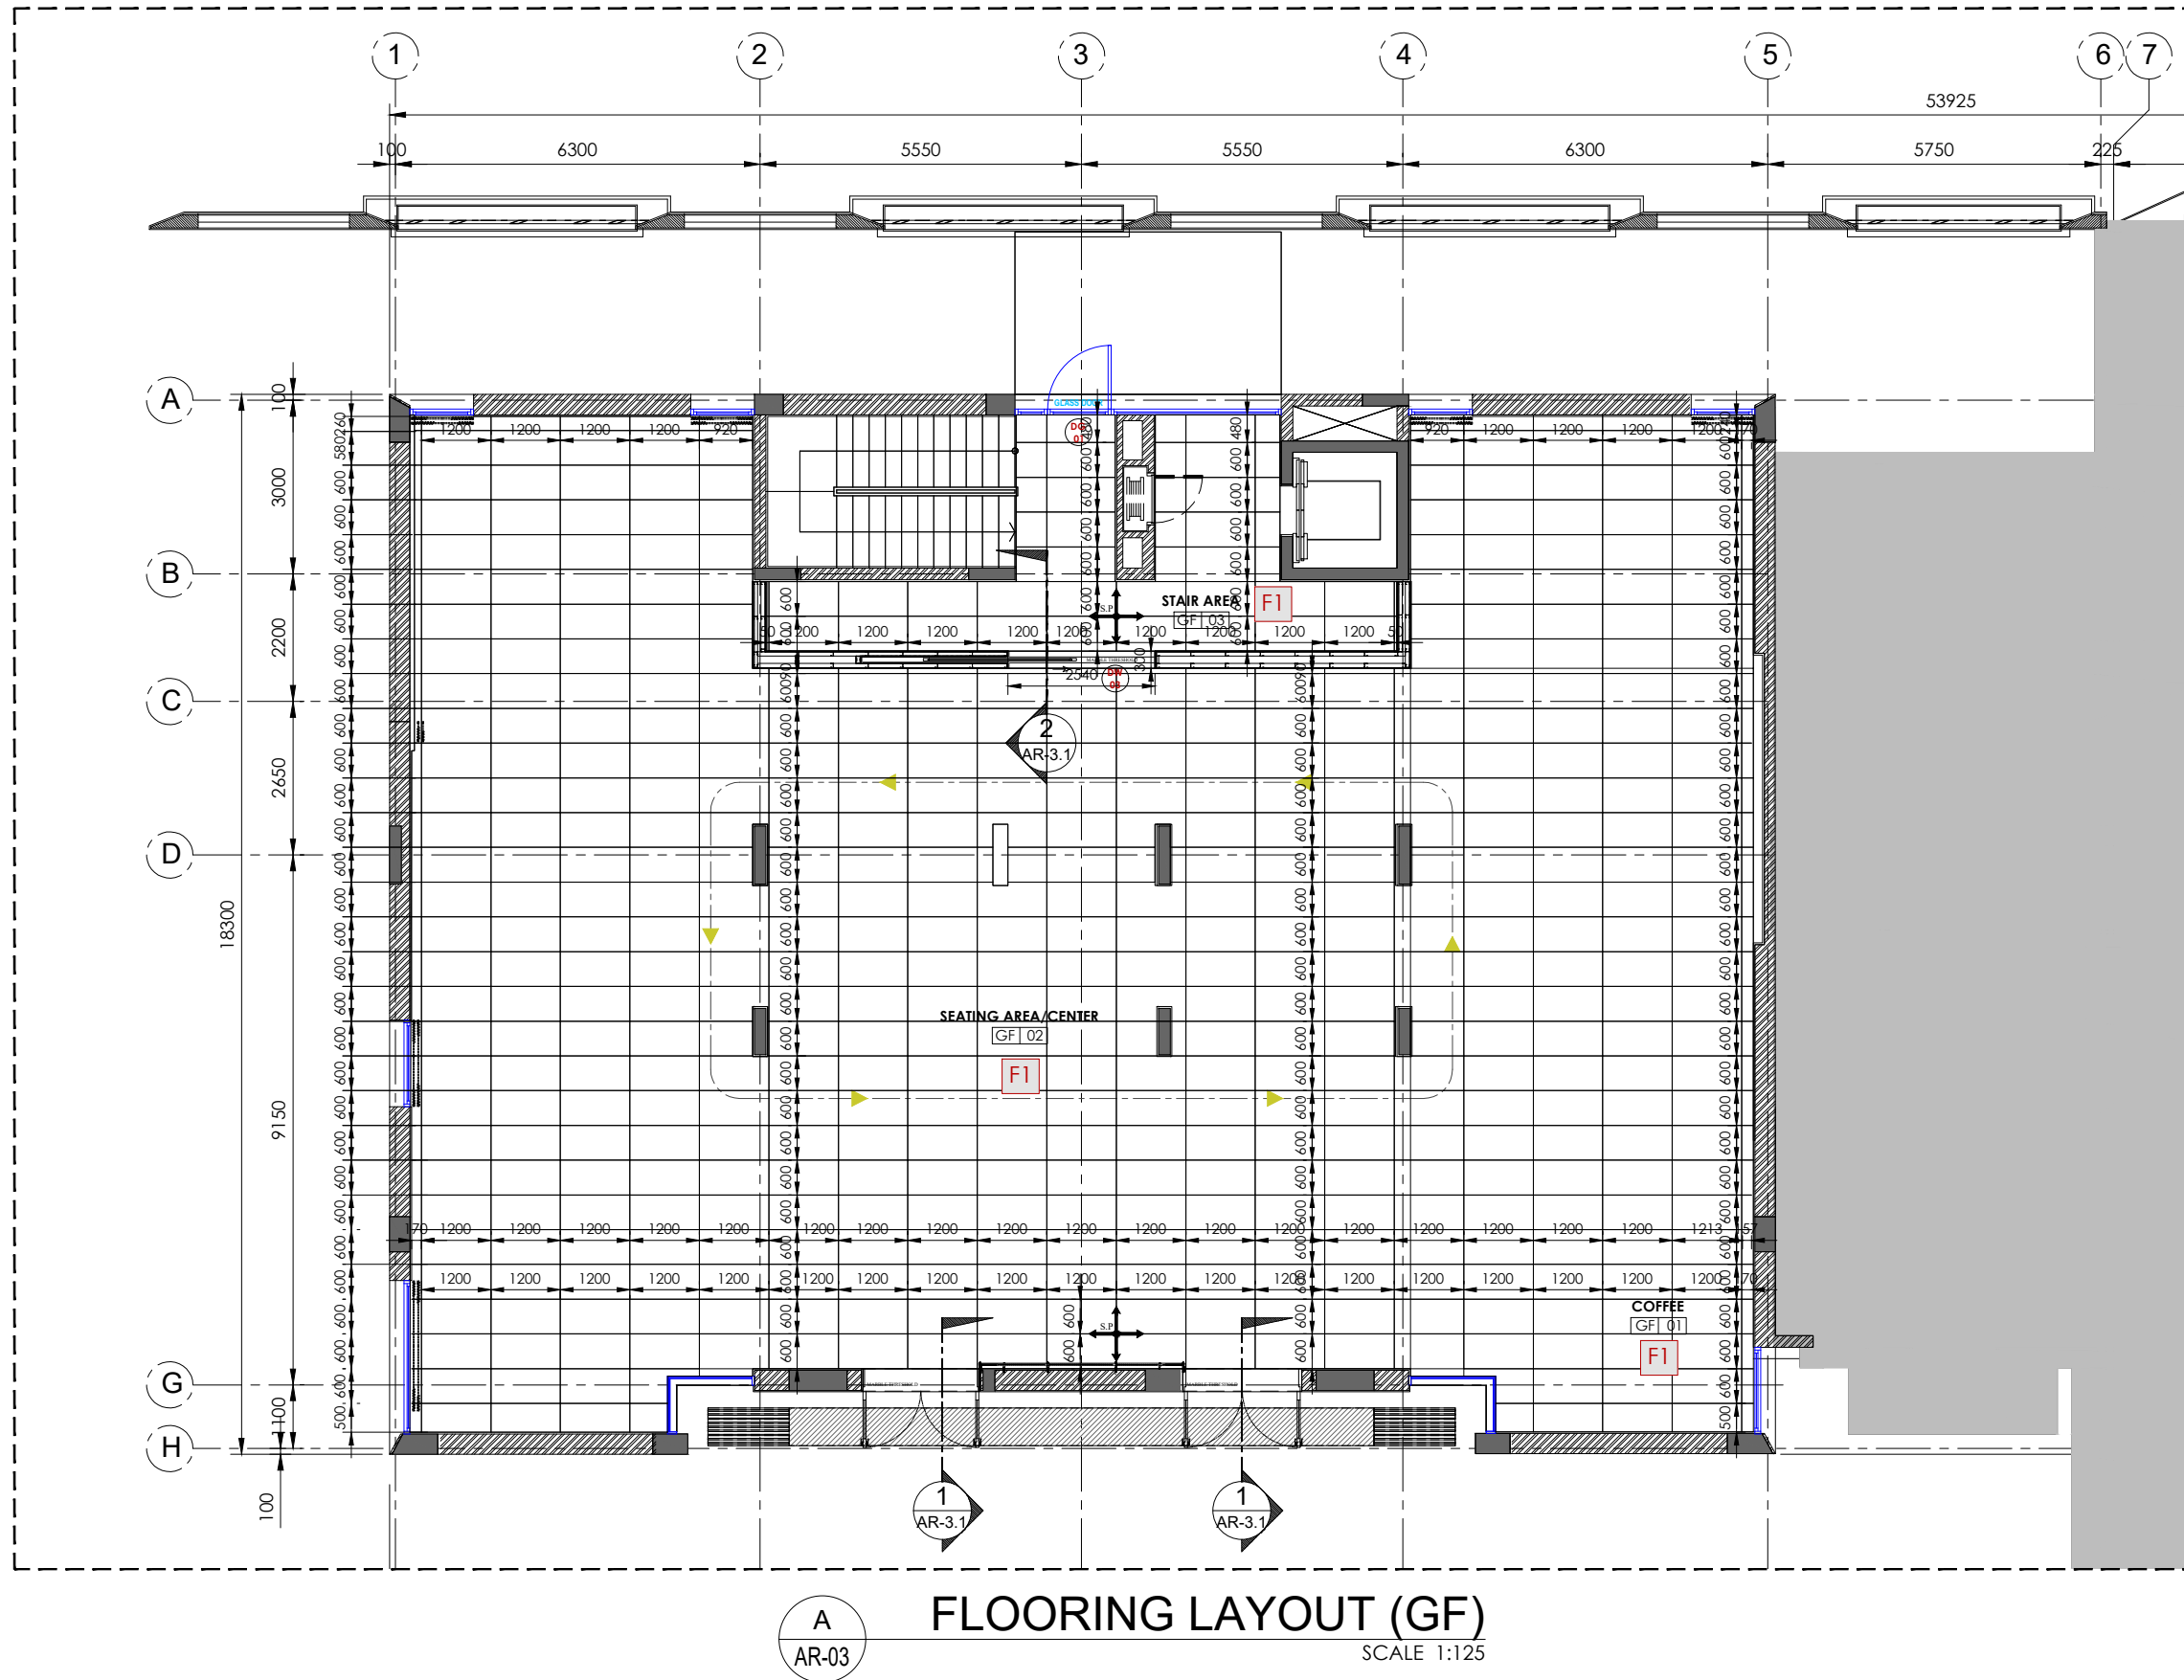

KEY PLAN

LEGEND:

CODE	SYMBOL	DESCRIPTION
F1		1200 x 600 CERAMIC WITH MARBLE EFFECT TILES (COLOR GRAY)
F2		1200 x 600 CERAMIC TILES (COLOR GRAY)
		MARBLE THRESHOLD (MARBLE (GRAY COLOR))
		MARBLE SKIRTING (GRAY COLOR) HEIGHT= 25 CM
		MARBLE SKIRTING (BLACK COLOR) HEIGHT= 25 CM
F3		8MM THICK MOVABLE CARPET
F4		8MM THICK MOVABLE CARPET
F5		8MM THICK MOVABLE CARPET
		STARTING POINT



NIRVANA INTERIOR DECORATION LLC.
Licence, No. 767759
Dubai, UAE.
P.O. box. 390952
Mobile: +966 505 25 24 24
Tel: +966 11 474 999 7
E-mail: info@nirvana-interiors.com
www.nirvana-interiors.com

CLIENT:

RADISSON GALLERY

REVISIONS:

NO.	REVISION	DATE	BY
0	ISSUED FOR APPROVAL	11.01.2023	JD

PROJECT:

RADISSON GALLERY OFFICE
Riyadh, K.S.A.

DRAWING TITLE:

GROUND FLOOR
FLOORING LAYOUT

DRAWING NO:

AR-03

DATE: 11.01.2023

SCALE @A3: AS SHOWN


DRAWN BY: JD

CHECKED BY: FJ

APPROVED BY: FJ


GENERAL NOTES:

- THIS DRAWING IS A COPYRIGHT.
- DIMENSIONS ARE NOT TO BE SCALED FROM THIS DRAWING.
- THE CONTRACTOR AND HIS SUBCONTRACTORS ARE TO VERIFY ALL DIMENSIONS ON SITE BEFORE MAKING ANY SHOP DRAWINGS AND BEFORE WORKS.
- ANY DISCREPANCIES, EITHER BETWEEN WRITTEN DIMENSIONS AND SITE DIMENSIONS OR BETWEEN THIS DRAWING AND OTHER CONSULTANTS' OR SUPPLIERS' DRAWINGS SHOULD BE BROUGHT TO THE IMMEDIATE ATTENTION OF NIRVANA INTERIORS BEFORE EXECUTING THE WORKS.
- THIS DRAWING IS TO BE READ IN CONJUNCTION WITH THE RELEVANT SPECIFICATIONS & DETAILS.

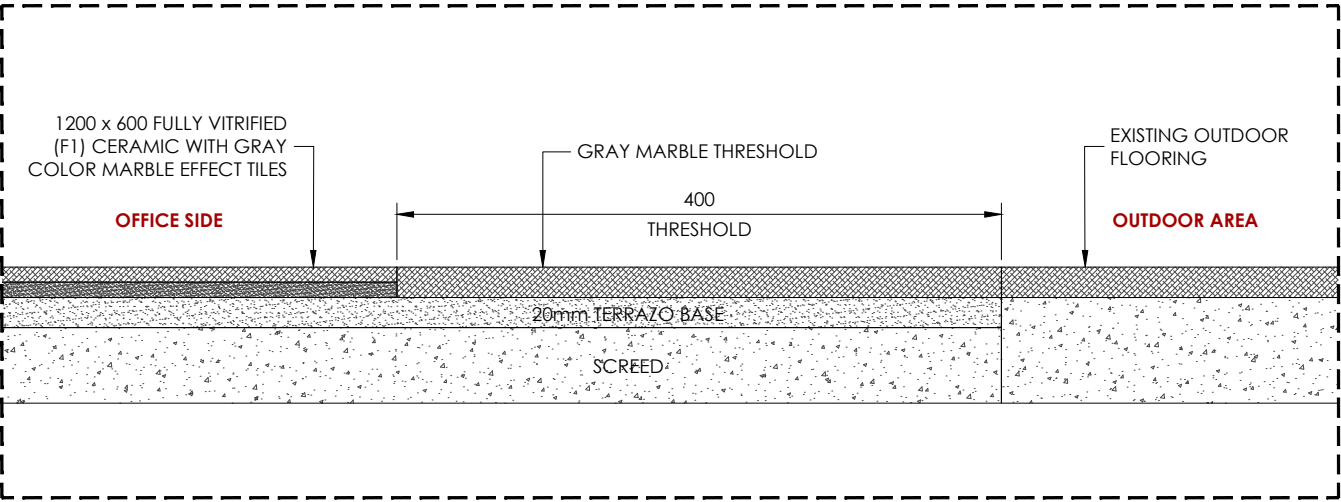

1
AR-03.1

DETAIL
SCALE 1:5

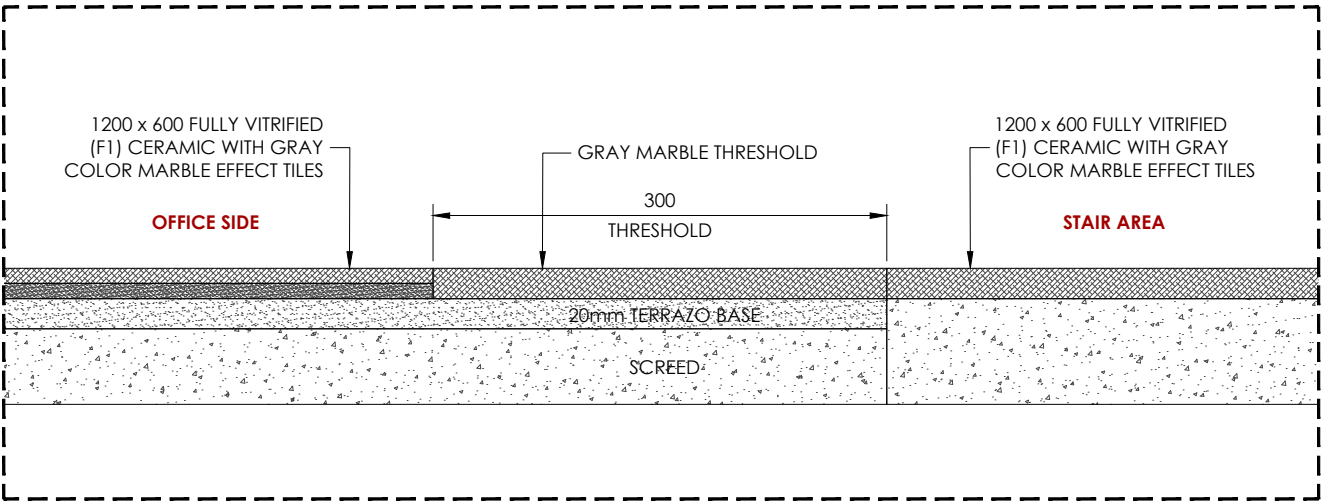

2
AR-03.1

DETAIL
SCALE 1:5



NIRVANA INTERIOR DECORATION LLC.
Licence, No. 767759
Dubai,UAE.
P.O. box. 390952
Mobile: +966 505 25 24 24
Tel: +966 11 474 999 7
E-mail: info@nirvana-interiors.com
www.nirvana-interiors.com

CLIENT:

RADISSON GALLERY

REVISIONS:

NO.	REVISION	DATE	BY
0	ISSUED FOR APPROVAL	11.01.2023	JD

PROJECT:

RADISSON GALLERY OFFICE
Riyadh, K.S.A.

DRAWING TITLE:

GROUND FLOOR
FLOORING DETAILS

DRAWING NO:

AR-03.1

DATE: 11.01.2023

SCALE @A3: AS SHOWN



DRAWN BY: JD

CHECKED BY: FJ

APPROVED BY: FJ

GENERAL NOTES:

1. THIS DRAWING IS A COPYRIGHT.
2. DIMENSIONS ARE NOT TO BE SCALED FROM THIS DRAWING.
3. THE CONTRACTOR AND HIS SUBCONTRACTORS ARE TO VERIFY ALL DIMENSIONS ON SITE BEFORE MAKING ANY SHOP DRAWINGS AND BEFORE WORKS.
4. ANY DISCREPANCIES, EITHER BETWEEN WRITTEN DIMENSIONS AND SITE DIMENSIONS OR BETWEEN THIS DRAWING AND OTHER CONSULTANTS' OR SUPPLIERS' DRAWINGS SHOULD BE BROUGHT TO THE IMMEDIATE ATTENTION OF NIRVANA INTERIORS BEFORE EXECUTING THE WORKS.
5. THIS DRAWING IS TO BE READ IN CONJUNCTION WITH THE RELEVANT SPECIFICATIONS & DETAILS.

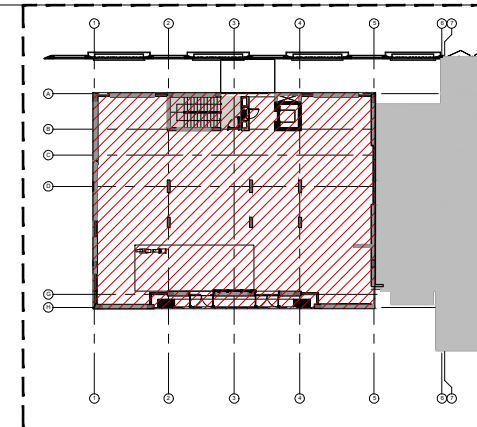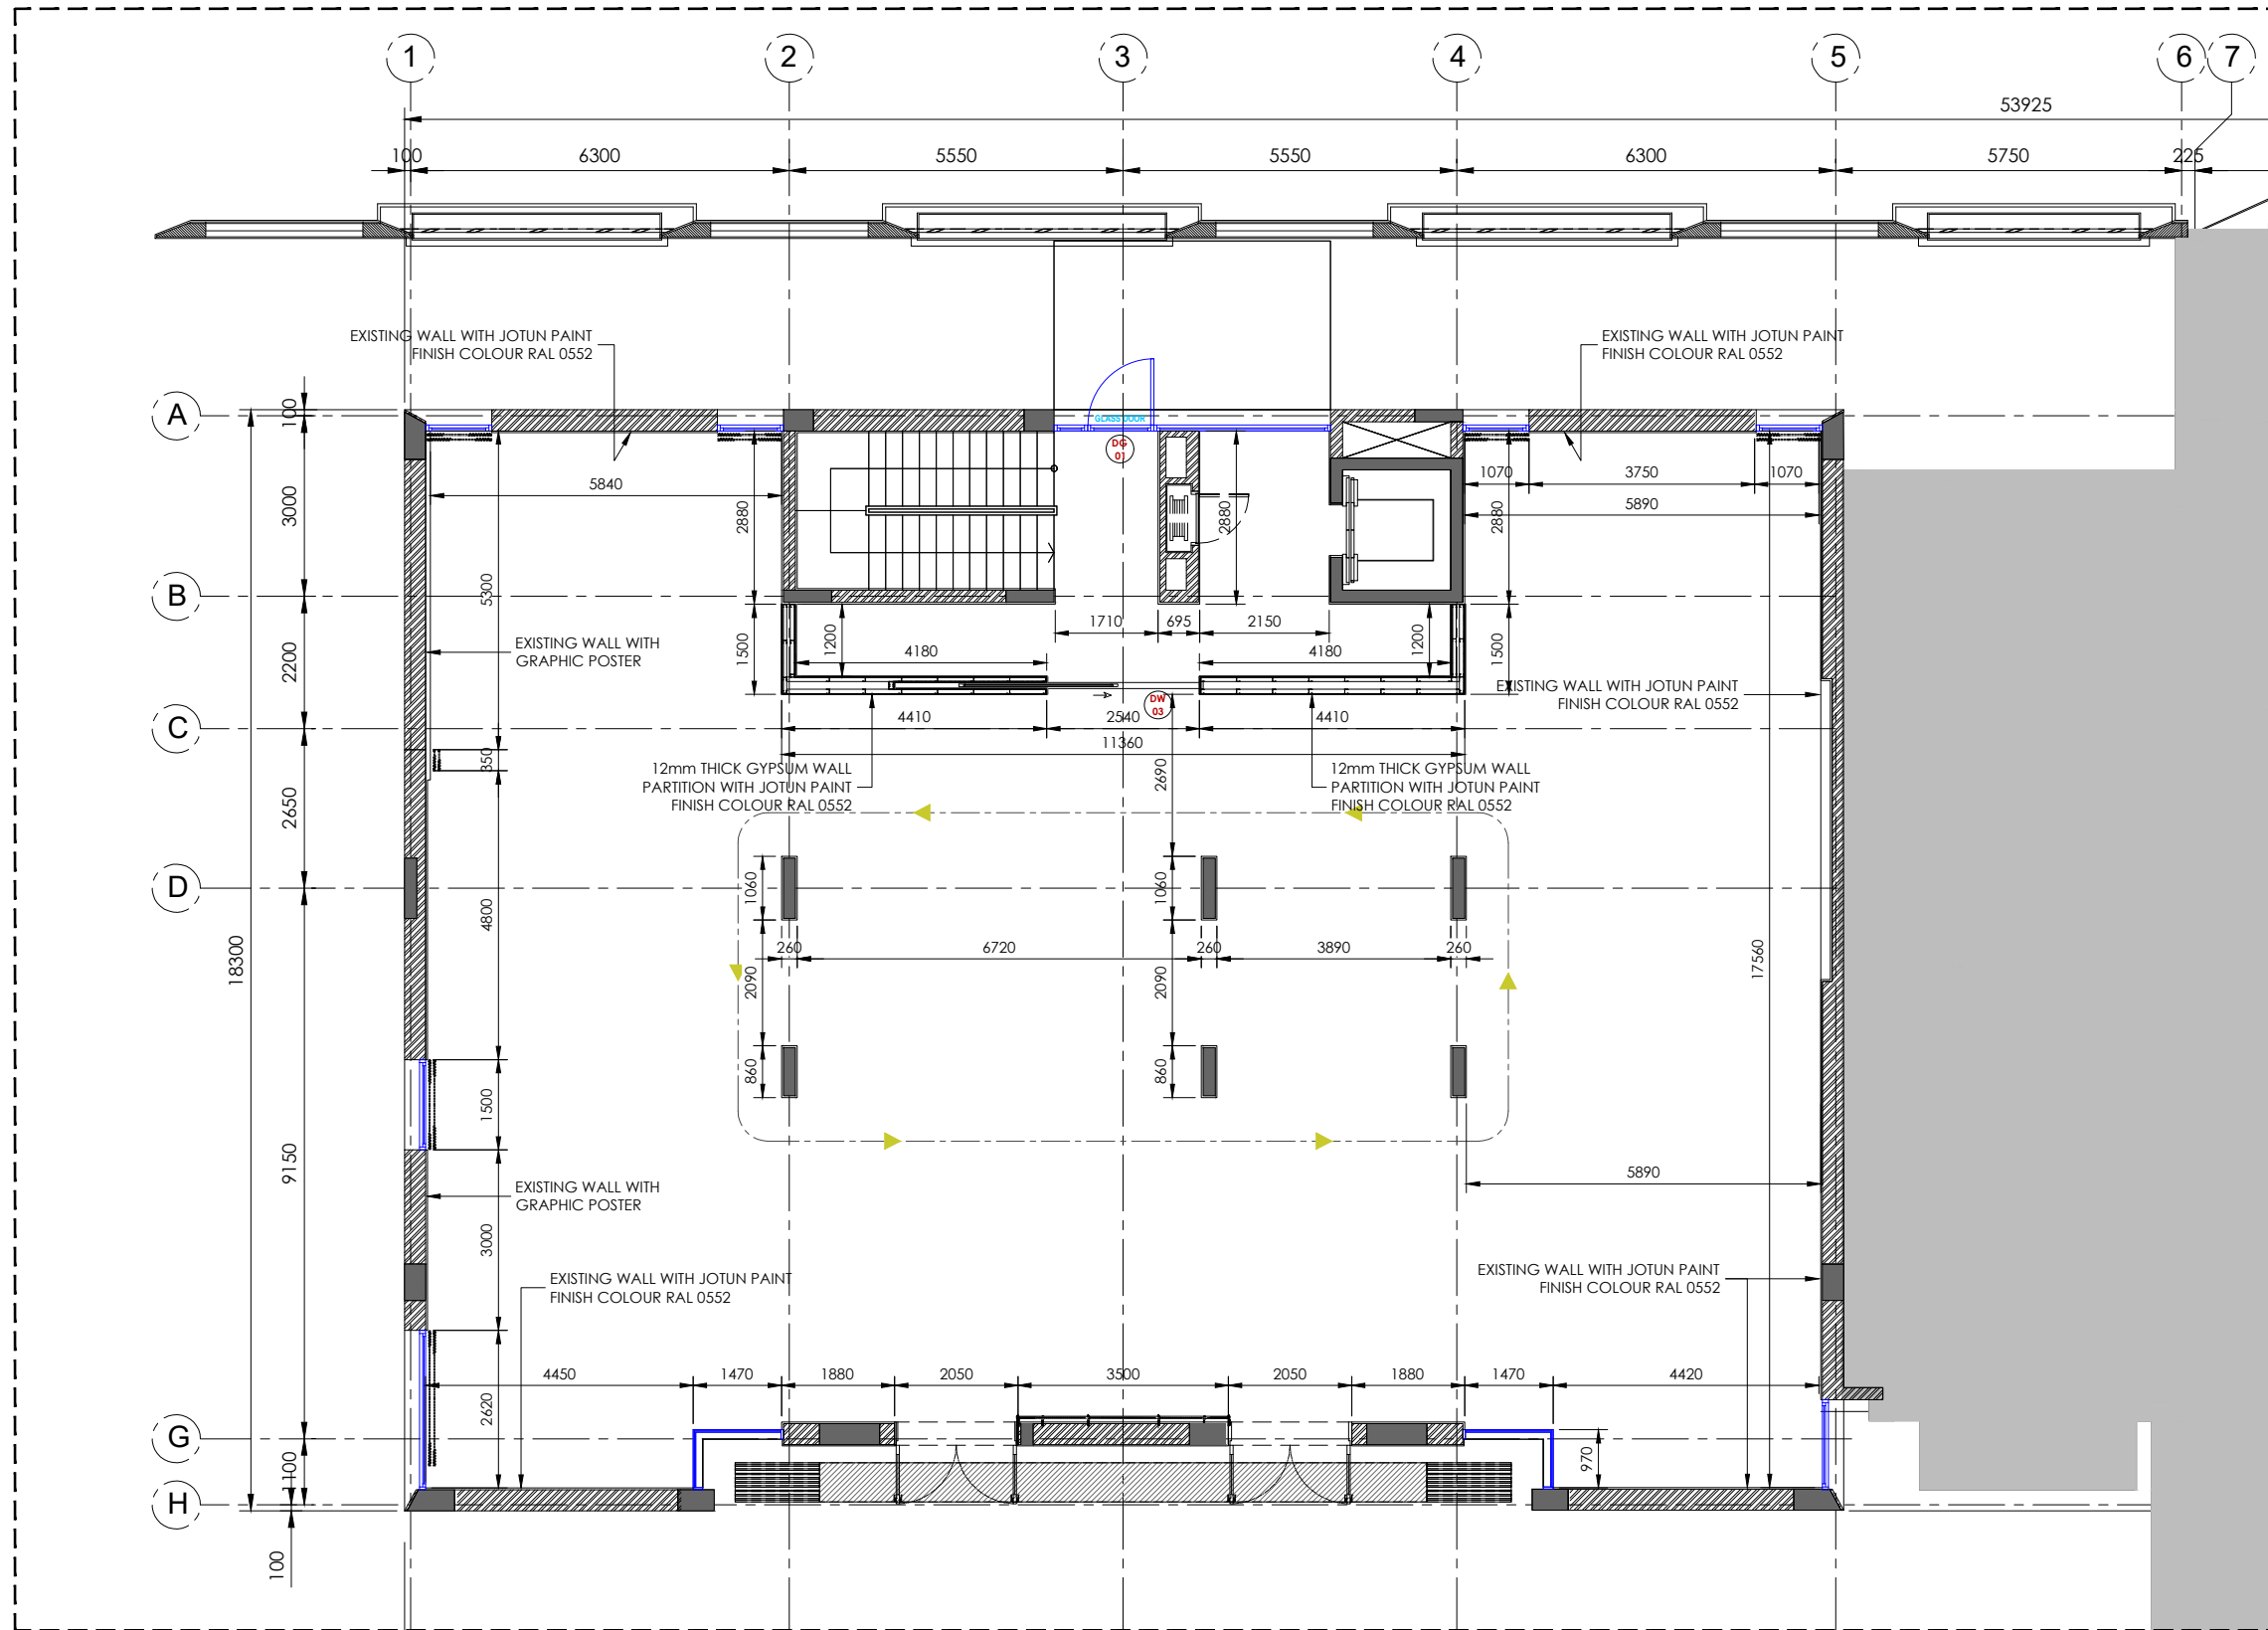

KEY PLAN

A WALL FINISHES LAYOUT (GF)
AR-04 SCALE 1:125



NIRVANA INTERIOR DECORATION LLC.
Licence, No. 767759
Dubai, UAE.
P.O. box. 390952
Mobile: +966 505 25 24 24
Tel: +966 11 474 999 7
E-mail: info@nirvana-interiors.com
www.nirvana-interiors.com

CLIENT:

RADISSON GALLERY

REVISIONS:

NO.	REVISION	DATE	BY
0	ISSUED FOR APPROVAL	11.01.2023	JD

PROJECT:

RADISSON GALLERY OFFICE
Riyadh, K.S.A.

DRAWING TITLE:

GROUND FLOOR
WALL FINISHES LAYOUT

DRAWING NO:

AR-04

DATE: 11.01.2023

SCALE @A3: AS SHOWN



DRAWN BY: JD

CHECKED BY: FJ

APPROVED BY: FJ

GENERAL NOTES:

- THIS DRAWING IS A COPYRIGHT.
- DIMENSIONS ARE NOT TO BE SCALED FROM THIS DRAWING.
- THE CONTRACTOR AND HIS SUBCONTRACTORS ARE TO VERIFY ALL DIMENSIONS ON SITE BEFORE MAKING ANY SHOP DRAWINGS AND BEFORE WORKS.
- ANY DISCREPANCIES, EITHER BETWEEN WRITTEN DIMENSIONS AND SITE DIMENSIONS OR BETWEEN THIS DRAWING AND OTHER CONSULTANTS' OR SUPPLIERS' DRAWINGS SHOULD BE BROUGHT TO THE IMMEDIATE ATTENTION OF NIRVANA INTERIORS BEFORE EXECUTING THE WORKS.
- THIS DRAWING IS TO BE READ IN CONJUNCTION WITH THE RELEVANT SPECIFICATIONS & DETAILS.

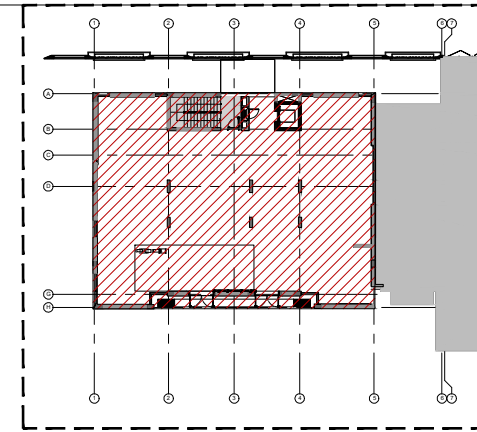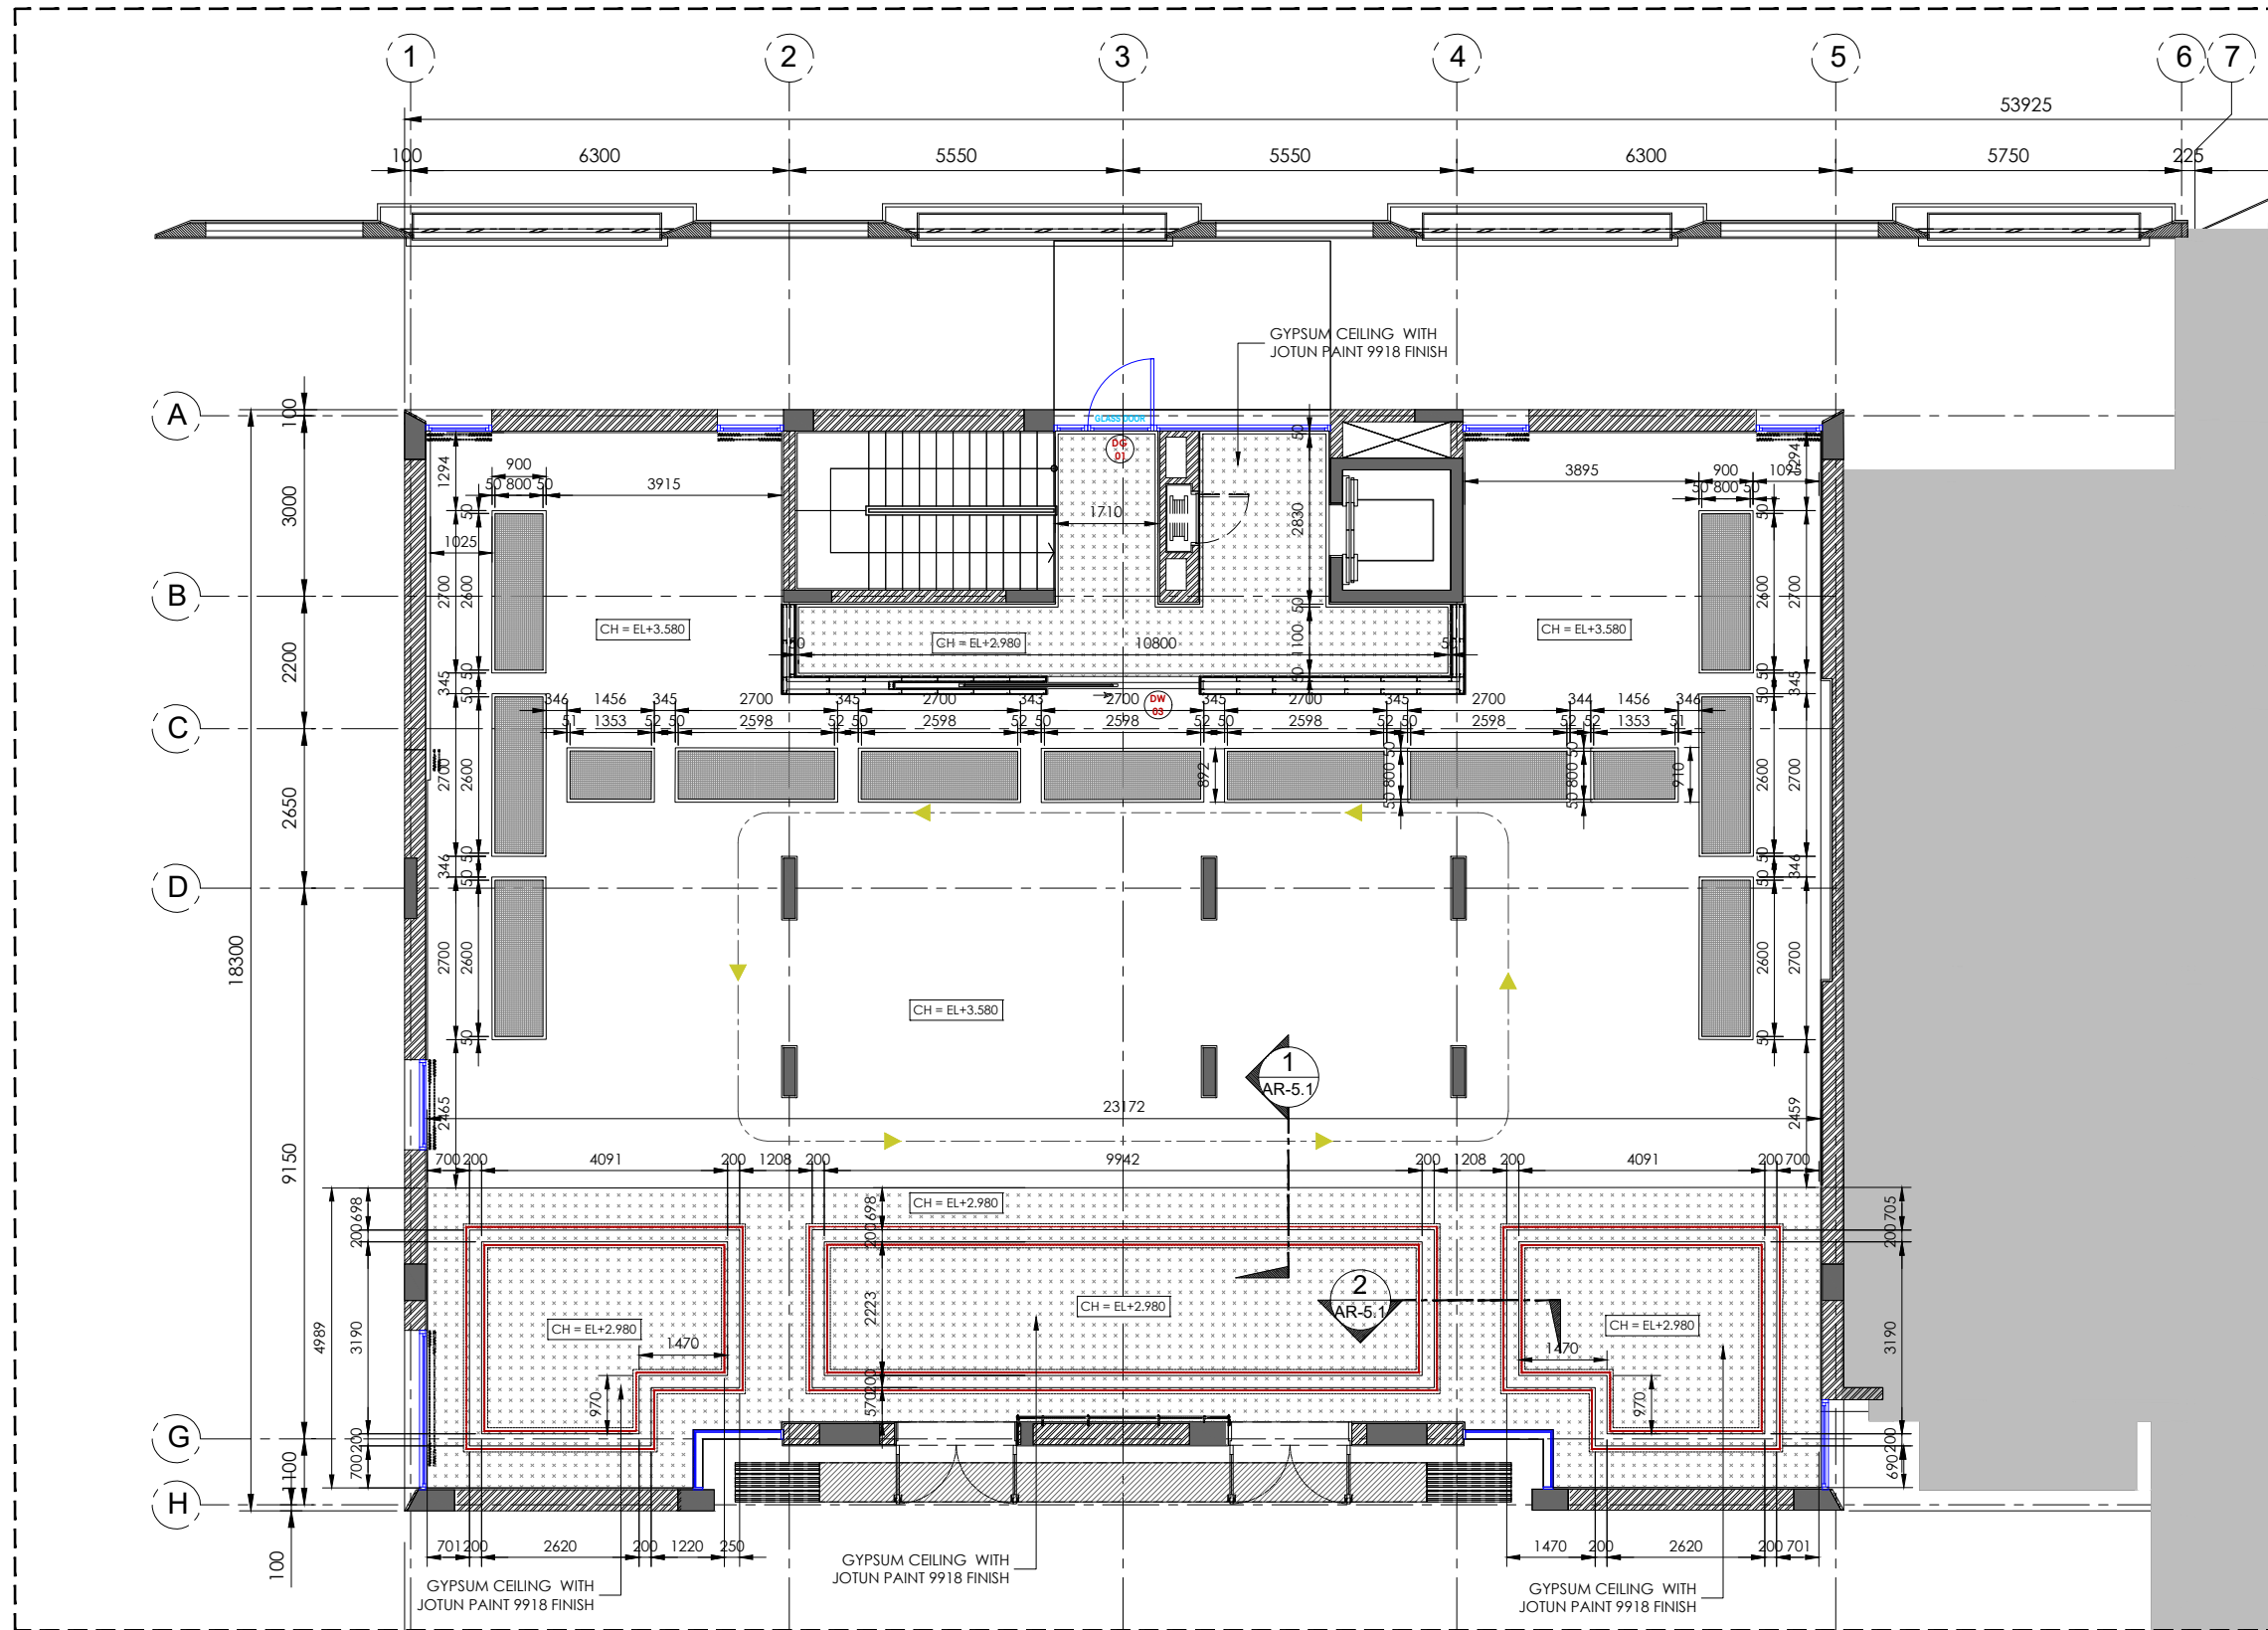

KEY PLAN

LEGEND:

SYMBOL	DESCRIPTION
	PENDANT GYPSUM BOARD FALSE CEILING
	PENDANT WATERPROOF GYPSUM BOARD FALSE CEILING
	INDUSTRIAL CEILING, PANELS
	INDUSTRIAL CEILING
	WALLPAPER
	MIND SOURCE
	BLACK PAINTED METAL, 3CM THICK

A REFLECTED CEILING PLAN (GF)
AR-05 SCALE 1:125



NIRVANA INTERIOR DECORATION LLC.
Licence, No. 767759
Dubai, UAE.
P.O. box. 390952
Mobile: +966 505 25 24 24
Tel: +966 11 474 999 7
E-mail: info@nirvana-interiors.com
www.nirvana-interiors.com

CLIENT:

RADISSON GALLERY

REVISIONS:

NO.	REVISION	DATE	BY
0	ISSUED FOR APPROVAL	11.01.2023	JD

PROJECT:

RADISSON GALLERY OFFICE
Riyadh, K.S.A.

DRAWING TITLE:

GROUND FLOOR
REFLECTED CEILING PLAN

DRAWING NO:

AR-05

DATE: 11.01.2023

SCALE @A3: AS SHOWN

DRAWN BY: JD

CHECKED BY: FJ



APPROVED BY: FJ

GENERAL NOTES:

- THIS DRAWING IS A COPYRIGHT.
- DIMENSIONS ARE NOT TO BE SCALED FROM THIS DRAWING.
- THE CONTRACTOR AND HIS SUBCONTRACTORS ARE TO VERIFY ALL DIMENSIONS ON SITE BEFORE MAKING ANY SHOP DRAWINGS AND BEFORE WORKS.
- ANY DISCREPANCIES, EITHER BETWEEN WRITTEN DIMENSIONS AND SITE DIMENSIONS OR BETWEEN THIS DRAWING AND OTHER CONSULTANTS' OR SUPPLIERS' DRAWINGS SHOULD BE BROUGHT TO THE IMMEDIATE ATTENTION OF NIRVANA INTERIORS BEFORE EXECUTING THE WORKS.
- THIS DRAWING IS TO BE READ IN CONJUNCTION WITH THE RELEVANT SPECIFICATIONS & DETAILS.



CLIENT:	REVISIONS:				PROJECT:	DRAWING NO:		GENERAL NOTES:	
RADISSON GALLERY	NO.	REVISION	DATE	BY	RADISSON GALLERY OFFICE Riyadh, K.S.A.	AR-05.1		1. THIS DRAWING IS A COPYRIGHT. 2. DIMENSIONS ARE NOT TO BE SCALED FROM THIS DRAWING. 3. THE CONTRACTOR AND HIS SUBCONTRACTORS ARE TO VERIFY ALL DIMENSIONS ON SITE BEFORE MAKING ANY SHOP DRAWINGS AND BEFORE WORKS. 4. ANY DISCREPANCIES, EITHER BETWEEN WRITTEN DIMENSIONS AND SITE DIMENSIONS OR BETWEEN THIS DRAWING AND OTHER CONSULTANTS' OR SUPPLIERS' DRAWINGS SHOULD BE BROUGHT TO THE IMMEDIATE ATTENTION OF NIRVANA INTERIORS BEFORE EXECUTING THE WORKS. 5. THIS DRAWING IS TO BE READ IN CONJUNCTION WITH THE RELEVANT SPECIFICATIONS & DETAILS.	
	0	ISSUED FOR APPROVAL	11.01.2023	JD		DATE: 11.01.2023			
						DRAWING TITLE:			
					GROUND FLOOR CEILING DETAILS	SCALE @A3: AS SHOWN			
						DRAWN BY:	JD		
						CHECKED BY:	FJ		
						APPROVED BY:	FJ		

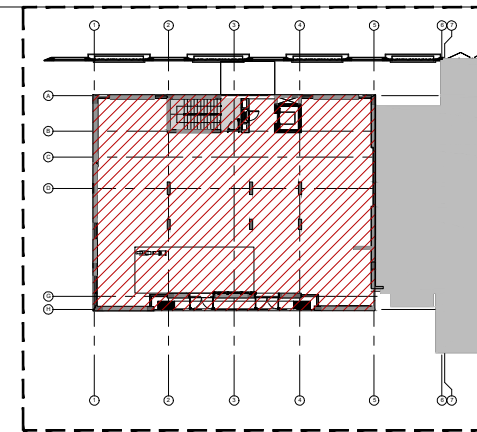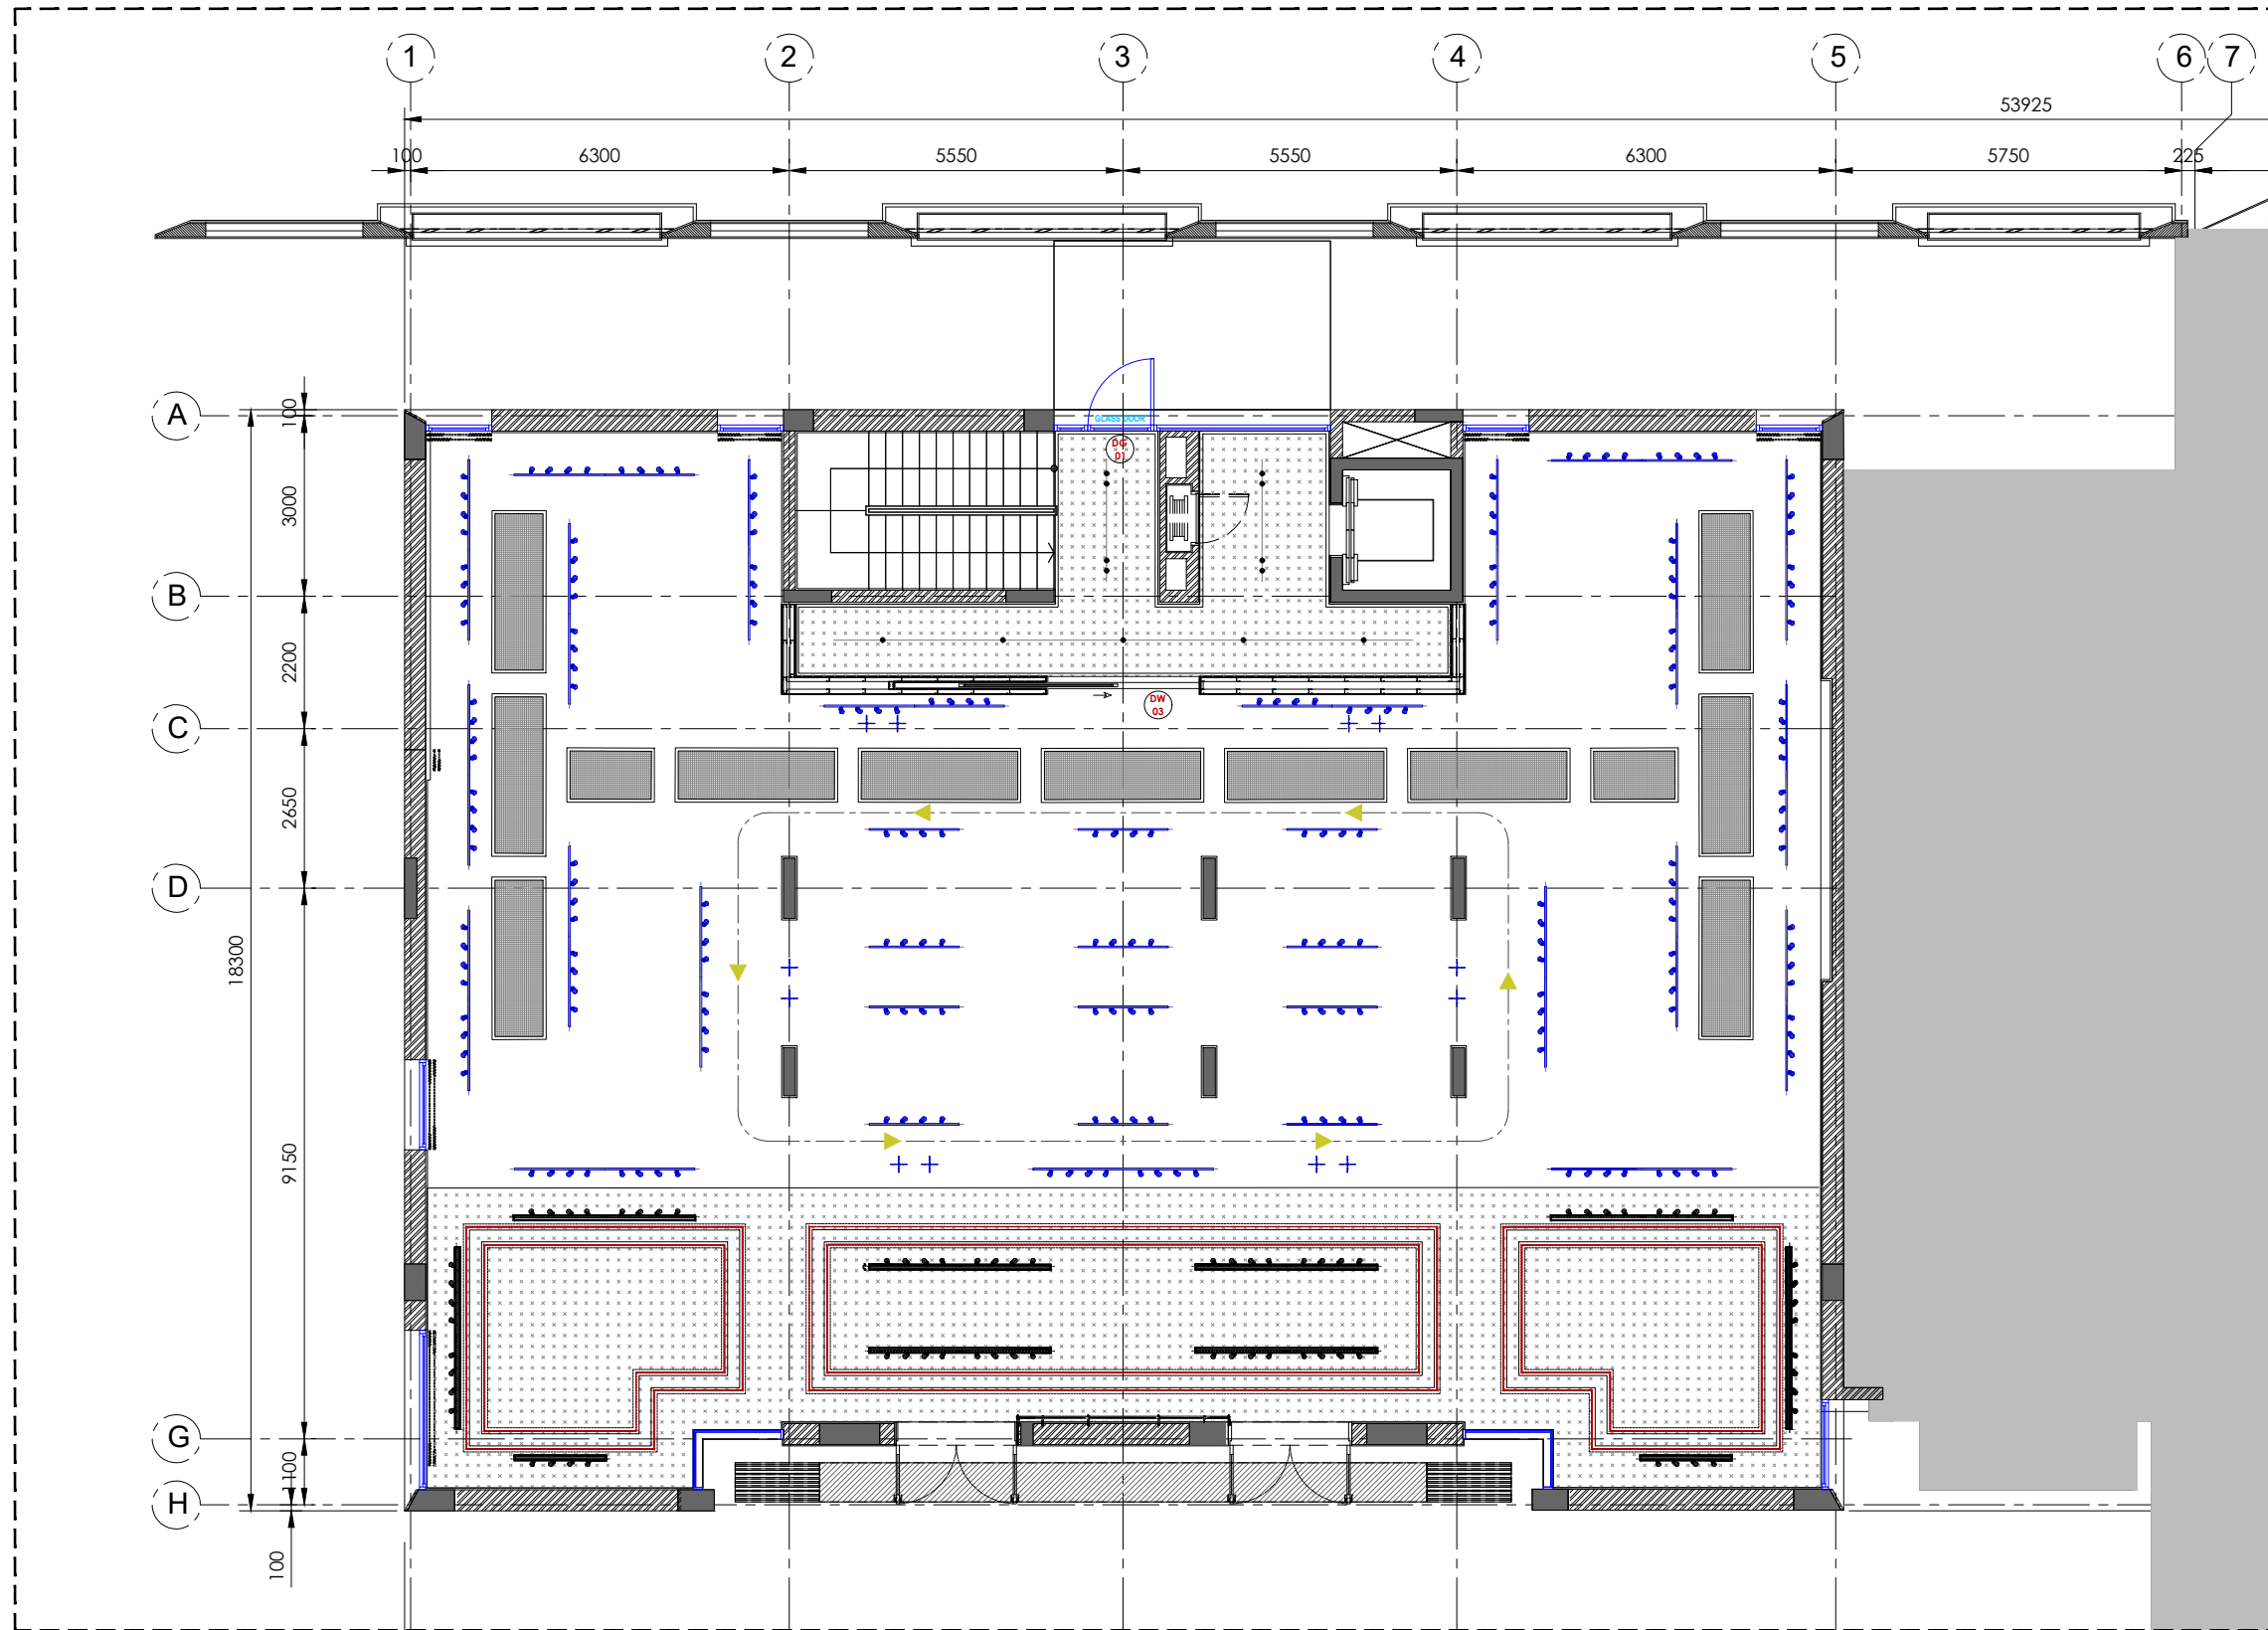

KEY PLAN

LEGEND:

SYMBOL	DESCRIPTION
	SPOTLIGHTS
	LED TRACK LIGHT
	GOLDEN HANGING LIGHT
	CHANDELIER LIGHTING
	CRYSTAL HANGING LIGHT
	COVE LIGHTING
	STAINLESS STEEL CEILING HANGING SUSPENSION BRACKET (HANGING)
	500KG

A
AR-06
COORDINATED CEILING PLAN (GF)
SCALE 1:125



NIRVANA INTERIOR DECORATION LLC.
Licence, No. 767759
Dubai, UAE.
P.O. box. 390952
Mobile: +966 505 25 24 24
Tel: +966 11 474 999 7
E-mail: info@nirvana-interiors.com
www.nirvana-interiors.com

CLIENT:

RADISSON GALLERY

REVISIONS:

NO.	REVISION	DATE	BY
0	ISSUED FOR APPROVAL	11.01.2023	JD

PROJECT:

RADISSON GALLERY OFFICE
Riyadh, K.S.A.

DRAWING TITLE:

GROUND FLOOR
COORDINATED CEILING PLAN

DRAWING NO:

AR-06

DATE: 11.01.2023

SCALE @A3: AS SHOWN


DRAWN BY: JD

CHECKED BY: FJ


APPROVED BY: FJ

GENERAL NOTES:

- THIS DRAWING IS A COPYRIGHT.
- DIMENSIONS ARE NOT TO BE SCALED FROM THIS DRAWING.
- THE CONTRACTOR AND HIS SUBCONTRACTORS ARE TO VERIFY ALL DIMENSIONS ON SITE BEFORE MAKING ANY SHOP DRAWINGS AND BEFORE WORKS.
- ANY DISCREPANCIES, EITHER BETWEEN WRITTEN DIMENSIONS AND SITE DIMENSIONS OR BETWEEN THIS DRAWING AND OTHER CONSULTANTS' OR SUPPLIERS' DRAWINGS SHOULD BE BROUGHT TO THE IMMEDIATE ATTENTION OF NIRVANA INTERIORS BEFORE EXECUTING THE WORKS.
- THIS DRAWING IS TO BE READ IN CONJUNCTION WITH THE RELEVANT SPECIFICATIONS & DETAILS.

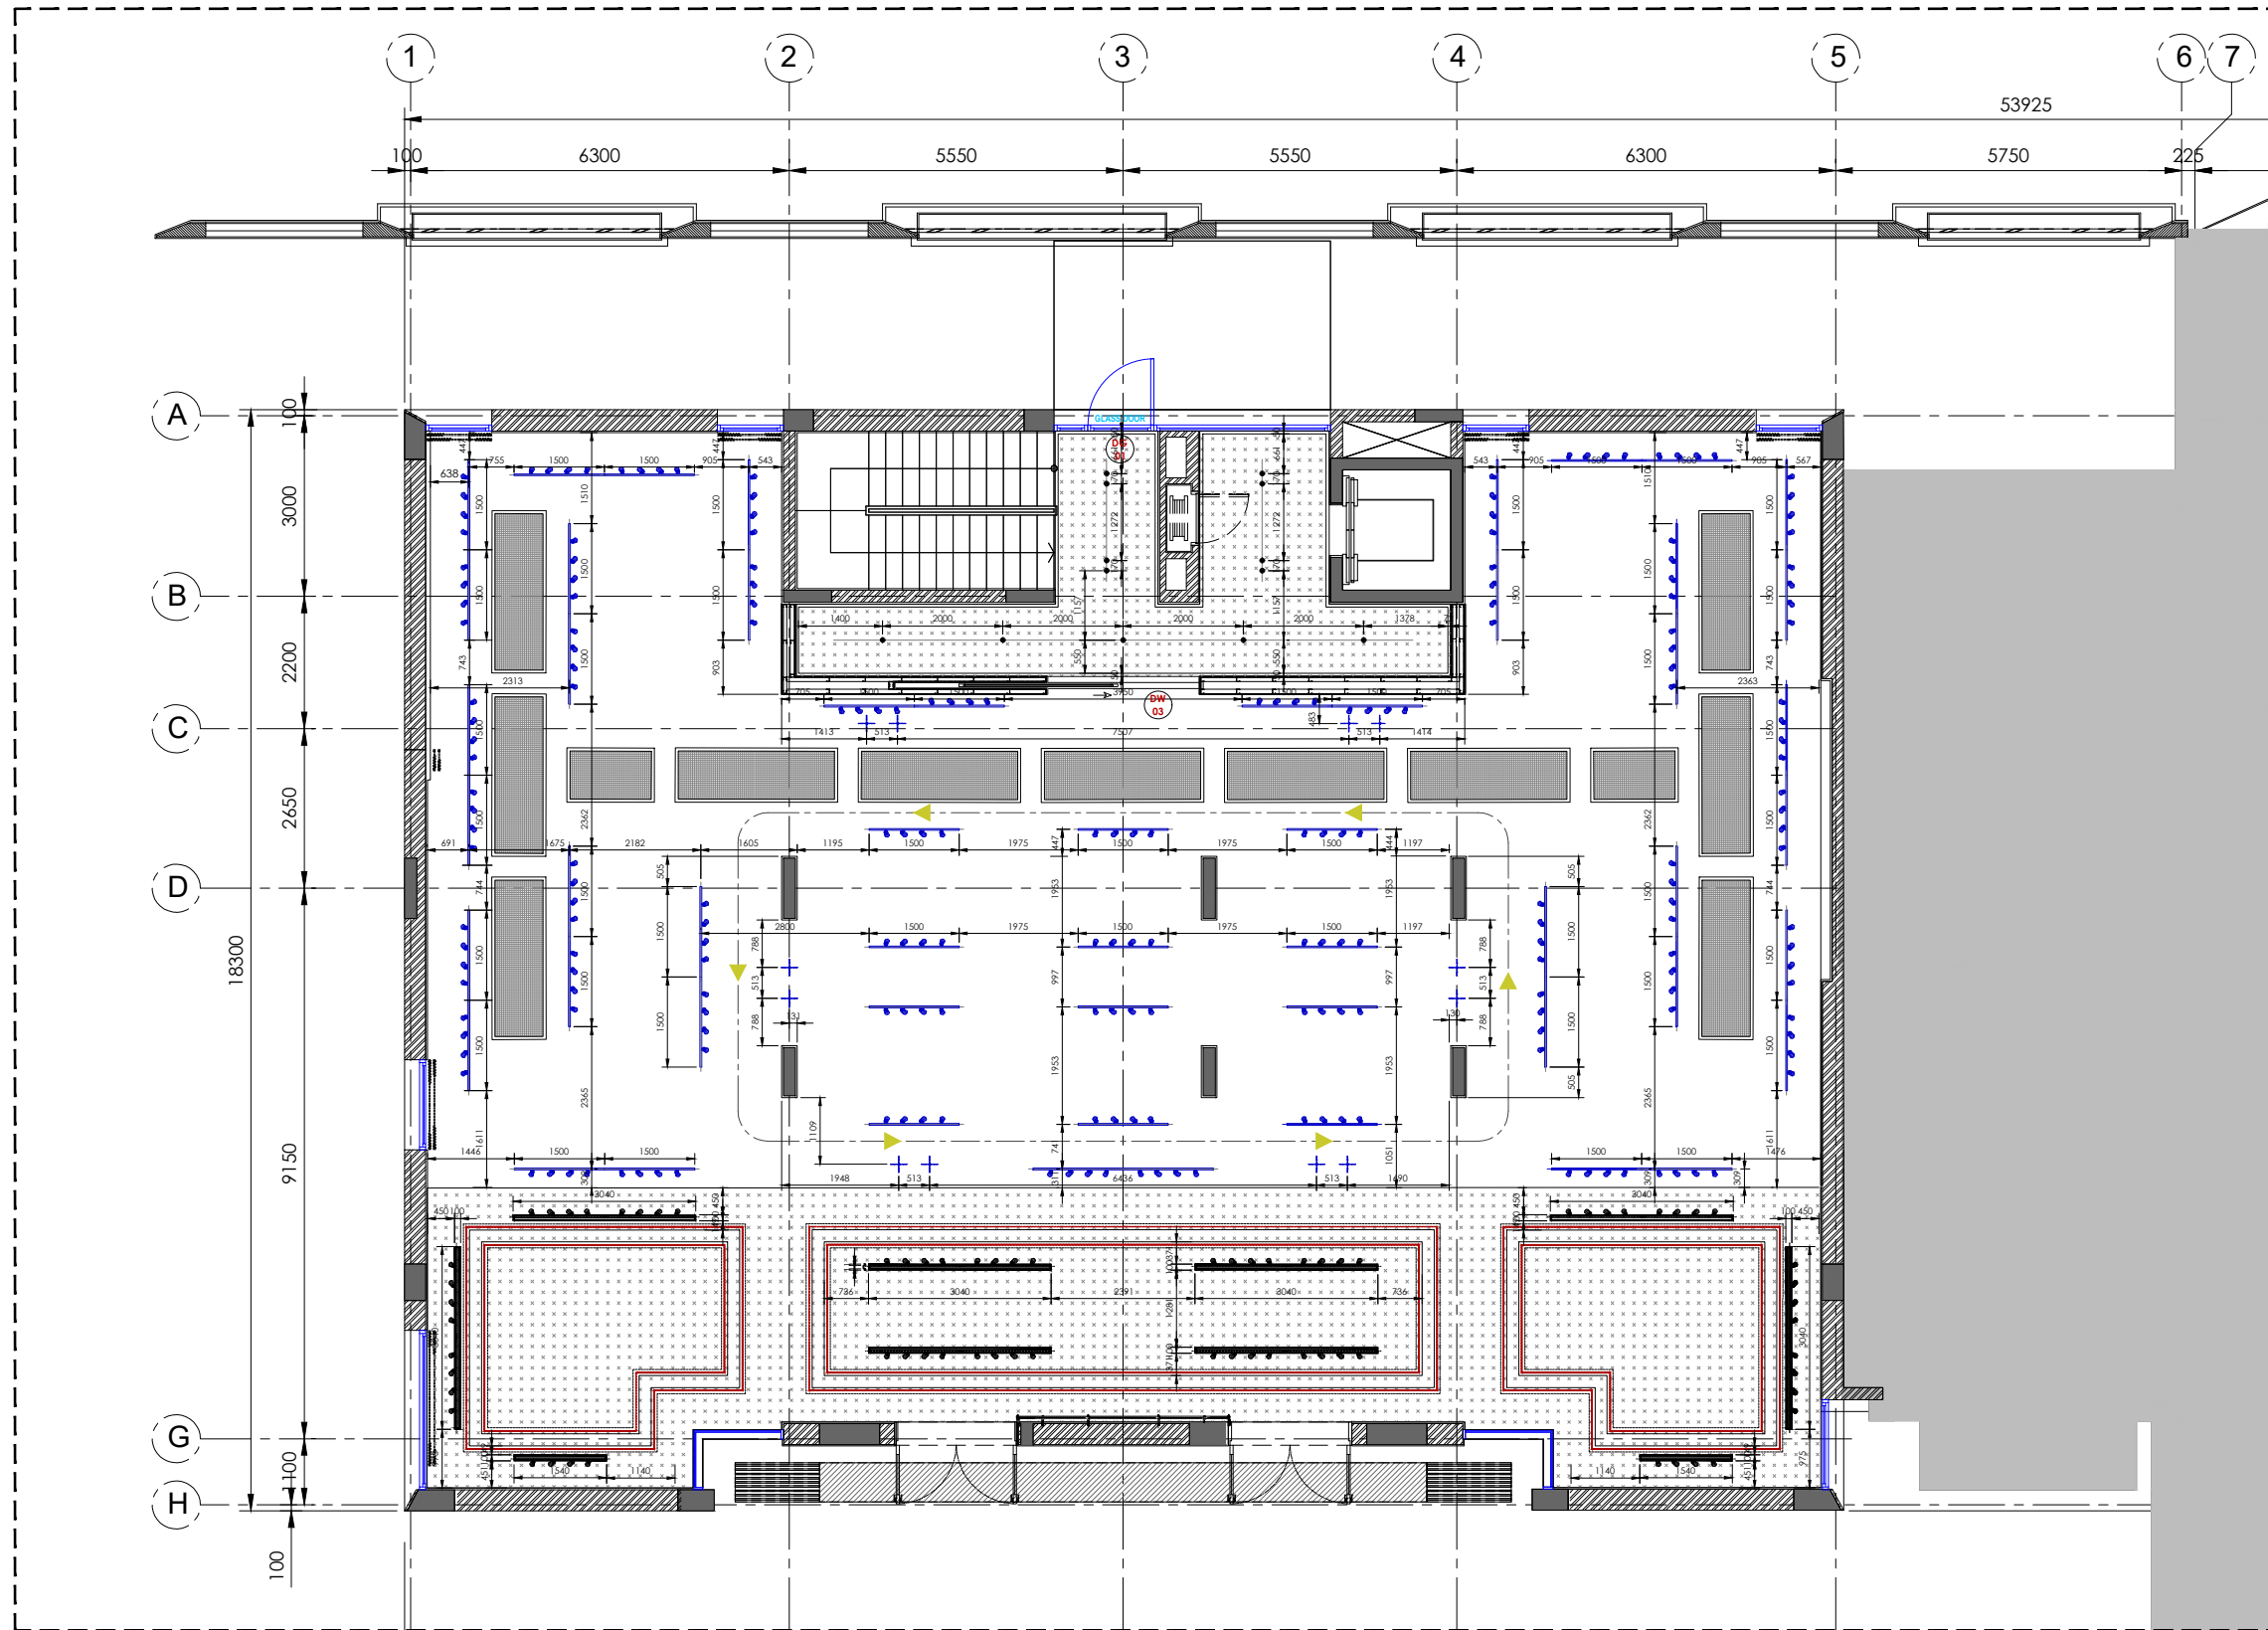

A
EL-01
LIGHTING LAYOUT (GF)
SCALE 1:125

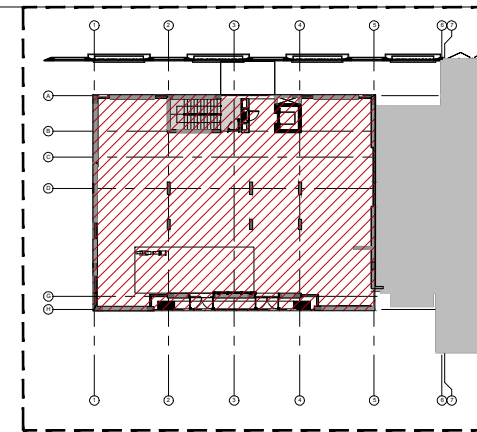

KEY PLAN

LEGEND:

SYMBOL	DESCRIPTION
	SPOTLIGHTS
	LED TRACK LIGHT
	GOLDEN HANGING LIGHT
	CHANDELIER LIGHTING
	CRYSTAL HANGING LIGHT
	COVE LIGHTING
	STAINLESS STEEL CEILING HANGING SUSPENSION BRACKET (HANGING)



NIRVANA INTERIOR DECORATION LLC.
Licence, No. 767759
Dubai, UAE.
P.O. box. 390952
Mobile: +966 505 25 24 24
Tel: +966 11 474 999 7
E-mail: info@nirvana-interiors.com
www.nirvana-interiors.com

CLIENT:

RADISSON GALLERY

REVISIONS:

NO.	REVISION	DATE	BY
0	ISSUED FOR APPROVAL	11.01.2023	JD

PROJECT:

RADISSON GALLERY OFFICE
Riyadh, K.S.A.

DRAWING TITLE:

GROUND FLOOR
LIGHTING LAYOUT

DRAWING NO:

EL-01

DATE: 11.01.2023

SCALE @A3: AS SHOWN


DRAWN BY: JD

CHECKED BY: FJ

APPROVED BY: FJ

GENERAL NOTES:

- THIS DRAWING IS A COPYRIGHT.
- DIMENSIONS ARE NOT TO BE SCALED FROM THIS DRAWING.
- THE CONTRACTOR AND HIS SUBCONTRACTORS ARE TO VERIFY ALL DIMENSIONS ON SITE BEFORE MAKING ANY SHOP DRAWINGS AND BEFORE WORKS.
- ANY DISCREPANCIES, EITHER BETWEEN WRITTEN DIMENSIONS AND SITE DIMENSIONS OR BETWEEN THIS DRAWING AND OTHER CONSULTANTS' OR SUPPLIERS' DRAWINGS SHOULD BE BROUGHT TO THE IMMEDIATE ATTENTION OF NIRVANA INTERIORS BEFORE EXECUTING THE WORKS.
- THIS DRAWING IS TO BE READ IN CONJUNCTION WITH THE RELEVANT SPECIFICATIONS & DETAILS.

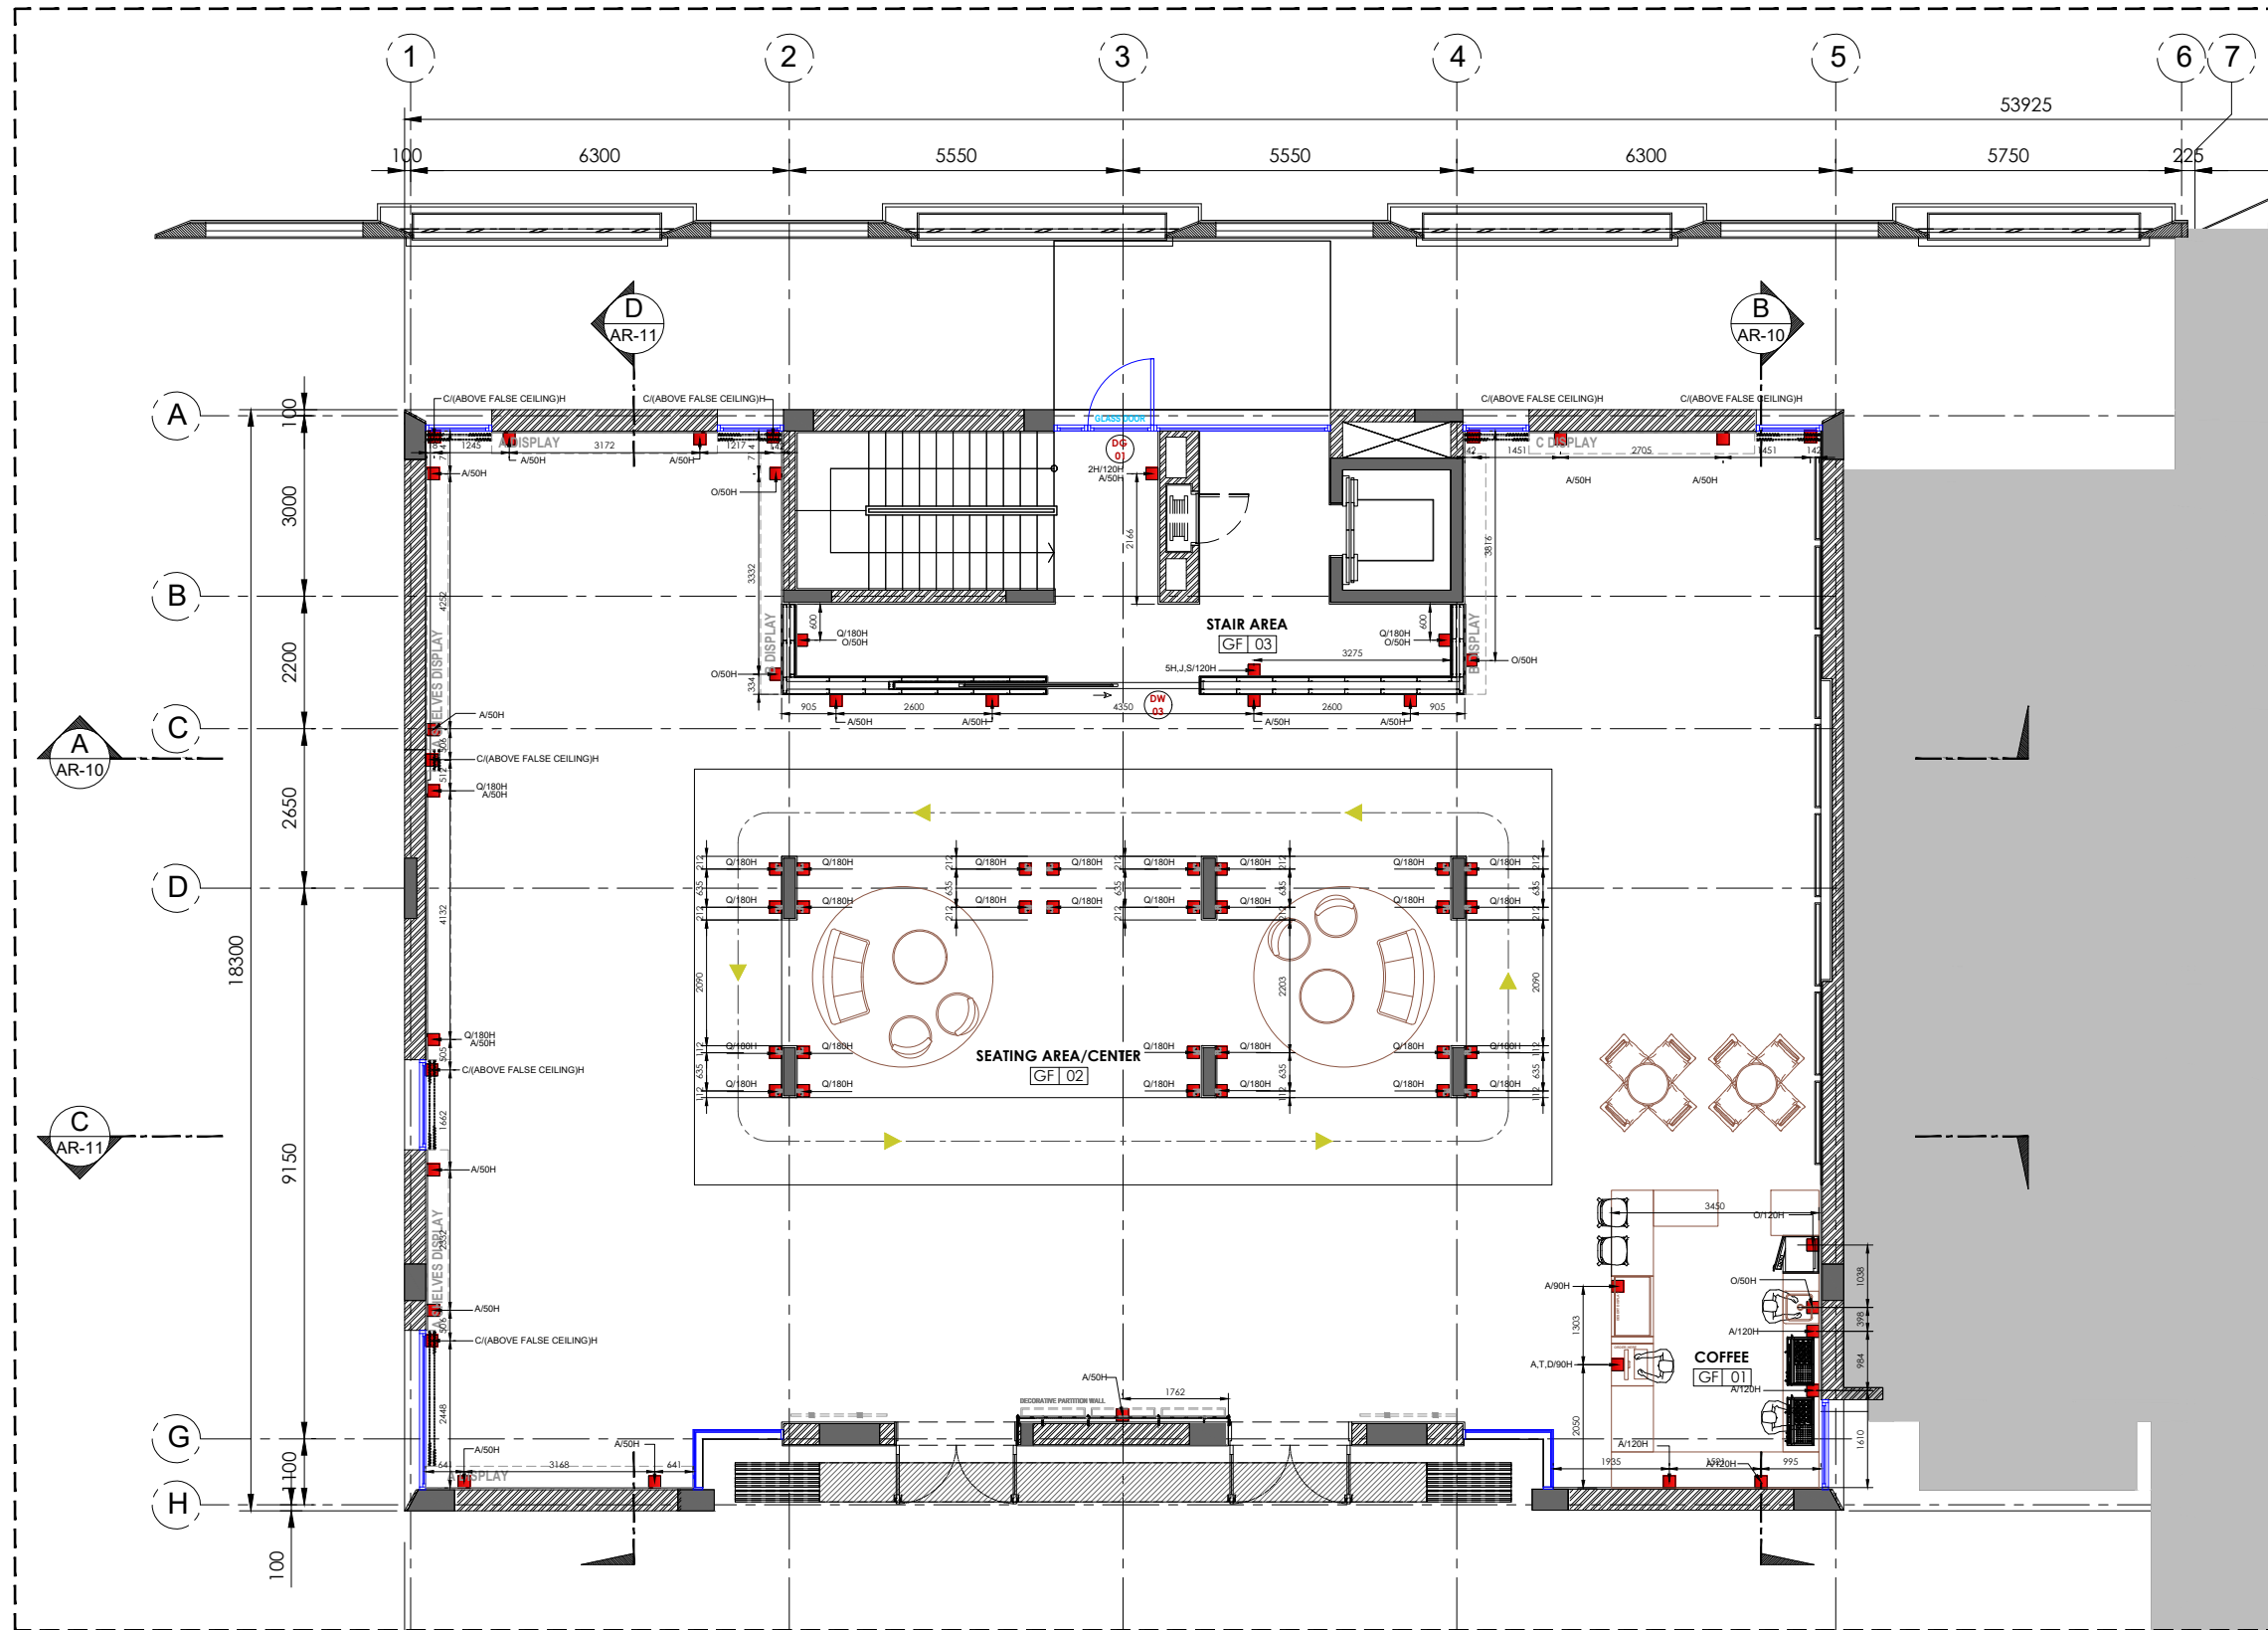

A POWER LAYOUT (GF)
EL-02
SCALE 1:125

KEY PLAN

LEGEND:

CODE	SYMBOL	DESCRIPTION
O		POWER OUTLET SINGLE (220 V) WALL & FLOOR MOUNTED
A		POWER OUTLET DOUBLE (220 V) WALL MOUNTED
B		POWER OUTLET DOUBLE (220 V) FLOOR MOUNTED
U		POWER OUTLET SINGLE +USB WALL MOUNTED
UD		POWER OUTLET DOUBLE + USB WALL MOUNTED
TV		POWER OUTLET DOUBLE (220 V) TELEVISION OUTLET WALL MOUNTED
T		TELEPHONE OUTLET WALL MOUNTED
CT		CAT 6 WALL MOUNTED
W		WI-FI OUTLET
D		DATA OUTLET
WH		SINGLE SWITCH WATER HEATER
G		4 GANG 1-WAY SWITCH
H		2 GANG 1-WAY SWITCH
I		2 GANG 2-WAY SWITCH
Q		ELECTRICAL WIRE POINT APPLIQUE & WALL LIGHTING
J		AIR CONDITIONER THERMOSTAT
F		SINGLE SWITCH FAN
KF		SINGLE SWITCH EXHAUST KITCHEN FAN
P		SINGLE SWITCH BELL
IN		INTERCOM WALL MOUNTED
SH		(ROLLER SHUTTER)
C		SINGLE SWITCH CURTAIN
S		SPEAKERS SWITCH
SC		SECURITY CAMERA
SV		SERVER SYSTEM
DC		DOOR CONTROL SYSTEM
K		CONTROL PANEL
FB		POWER OUTLET DOUBLE (220 V) TELEPHONE OUTLET DATA OUTLET FLOOR MOUNTED
R		SINGLE SWITCH ELEVATOR BUTTONS
SP		SMART PANEL CONTROL

NOTE:
UNLESS INDICATED ON THE PLAN,
LOCATIONS & MOUNTING HEIGHTS
OF SWITCHES IS AS SHOWN BELOW.

NOTE:
(BEDROOM)
SIDE TABLE SWITCH
(DOUBLE DIRECTION)
(Side Table Switch)
Mounting 14-15.50 cm.

* ALL DIMENSIONS ARE IN METERS *



NIRVANA INTERIOR DECORATION LLC.
Licence, No. 767759
Dubai, UAE.
P.O. box. 390952
Mobile: +966 505 25 24 24
Tel: +966 11 474 999 7
E-mail: info@nirvana-interiors.com
www.nirvana-interiors.com

CLIENT:

RADISSON GALLERY

REVISIONS:

NO.	REVISION	DATE	BY
0	ISSUED FOR APPROVAL	11.01.2023	JD

PROJECT:

RADISSON GALLERY OFFICE
Riyadh, K.S.A.

DRAWING TITLE:

POWER LAYOUT

DRAWING NO:

EL-02

DATE: 11.01.2023

SCALE @A3: AS SHOWN

DRAWN BY: JD

CHECKED BY: FJ

APPROVED BY: FJ

GENERAL NOTES:

- THIS DRAWING IS A COPYRIGHT.
- DIMENSIONS ARE NOT TO BE SCALED FROM THIS DRAWING.
- THE CONTRACTOR AND HIS SUBCONTRACTORS ARE TO VERIFY ALL DIMENSIONS ON SITE BEFORE MAKING ANY SHOP DRAWINGS AND BEFORE WORKS.
- ANY DISCREPANCIES, EITHER BETWEEN WRITTEN DIMENSIONS AND SITE DIMENSIONS OR BETWEEN THIS DRAWING AND OTHER CONSULTANTS' OR SUPPLIERS' DRAWINGS SHOULD BE BROUGHT TO THE IMMEDIATE ATTENTION OF NIRVANA INTERIORS BEFORE EXECUTING THE WORKS.
- THIS DRAWING IS TO BE READ IN CONJUNCTION WITH THE RELEVANT SPECIFICATIONS & DETAILS.